



SCALE OF CORRIDORS 1/8" = 1'-0"

NOTES:
 1. SEE PLAN FOR LOCATION OF ALL NEW WORK.
 2. ALL NEW WORK TO BE INSTALLED IN ACCORDANCE WITH THE LATEST EDITIONS OF THE NATIONAL FIRE PROTECTION ASSOCIATION (NFPA) CODES AND STANDARDS.
 3. ALL NEW WORK TO BE INSTALLED IN ACCORDANCE WITH THE LATEST EDITIONS OF THE NATIONAL ELECTRICAL CODE (NEC) AND NATIONAL FIRE ALARM CODE (NFAC).
 4. ALL NEW WORK TO BE INSTALLED IN ACCORDANCE WITH THE LATEST EDITIONS OF THE INTERNATIONAL MECHANICAL EXAMINERS' INSTITUTE (IMEx) CODES AND STANDARDS.

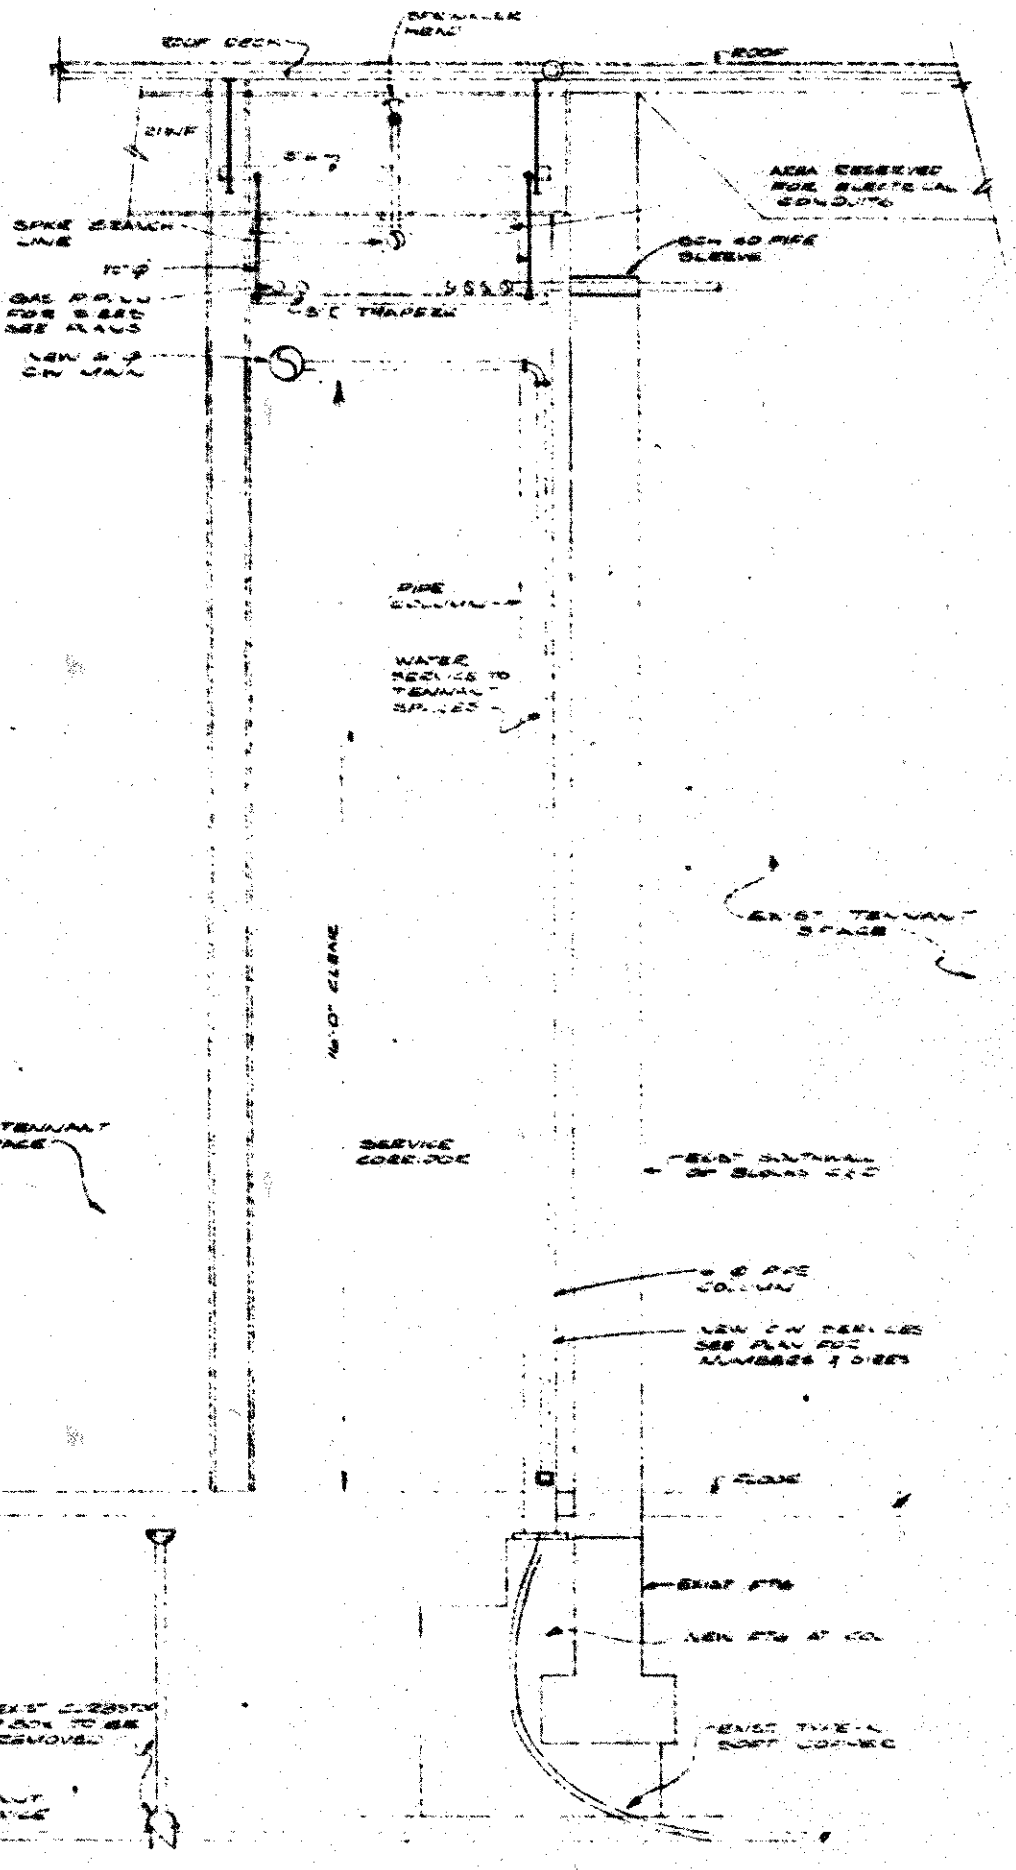

MECHANICAL LEGEND & SYMBOLS

—	CW	COLD WATER
—	SW	SEWER
—	S	SEWER BURED OR BELOW SLAB
—	NS	SEWER NOT BURED
—	V	VENT
—	FP	FIRE PROTECTION
—	SV	SAFETY VALVE
—	CV	BALL OR BUTTERFLY VALVE
—	CHV	CHECK VALVE
—	U	UNION
—	TH	TERMINATING
—	TR	THERMISTAT
—	TRM	THERMISTOR
—	DT	DUCT TAPPING VALVES
—	CC	CLAMP CONNECTION
—	VCD	VOLUME CONTROL DAMPER
—	CD	CLEANOUT
—	FD	FLOOR DRAIN
—	ED	EDGE DRAIN
—	EC	EDGE CONDUIT
—	SB	SAFETY BEWEE
—	SB	STORY BASE
—	MS	MANHOLE
—	CS	CATCH BASIN
—	TS	TRAP STOP ELEVATION
—	VCP	VITRIFIED CLAY PIPE
—	CP	CONCRETE PIPE
—	CF	CAST IRON PIPE
—	WH	WALL HYDRANT
—	SA	SUPPLY AIR
—	SA	RETURN AIR
—	OA	OUTSIDE AIR
—	EA	EXHAUST AIR
—	CD	CLEANOUT DAMPER
—	EM	ELECTRIC MOUNTED SOL
—	FD	FIRE DAMPER
—	MC	MECHANICAL CONTRACTOR
—	GC	GENERAL CONTRACTOR
—	CP	COPY TOP
—	CH	CHIMNEY
—	ES	EXISTING
—	NS	NEW

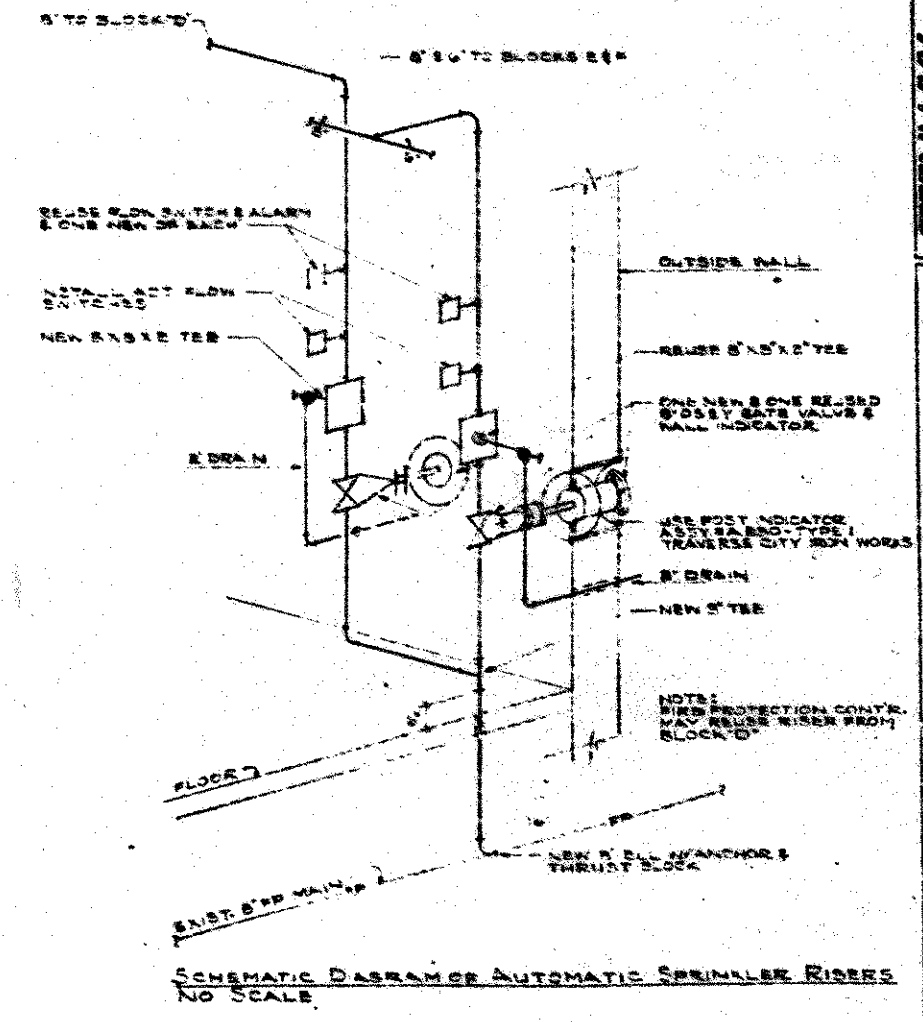

FILE NO. 10000
 DATE 12-15-78
 PROJECT NO. 10000
 SHEET NO. 10000
 MECHANICAL DETAILS
 CONCORD MALL
 ELKHART, INDIANA
 STEENWYK - THRALL ARCHITECTS
 35 Lafayette NE, Grand Rapids, Michigan 49503
 PHONE 616-941-1111
 FAX 616-941-1112

