




Block 'C' Electrical Room Elevations & Details
 SCALE: 1/8" = 1'-0"
 NOTE: SHADY PORTIONS DENOTES NEW EQUIPMENT.

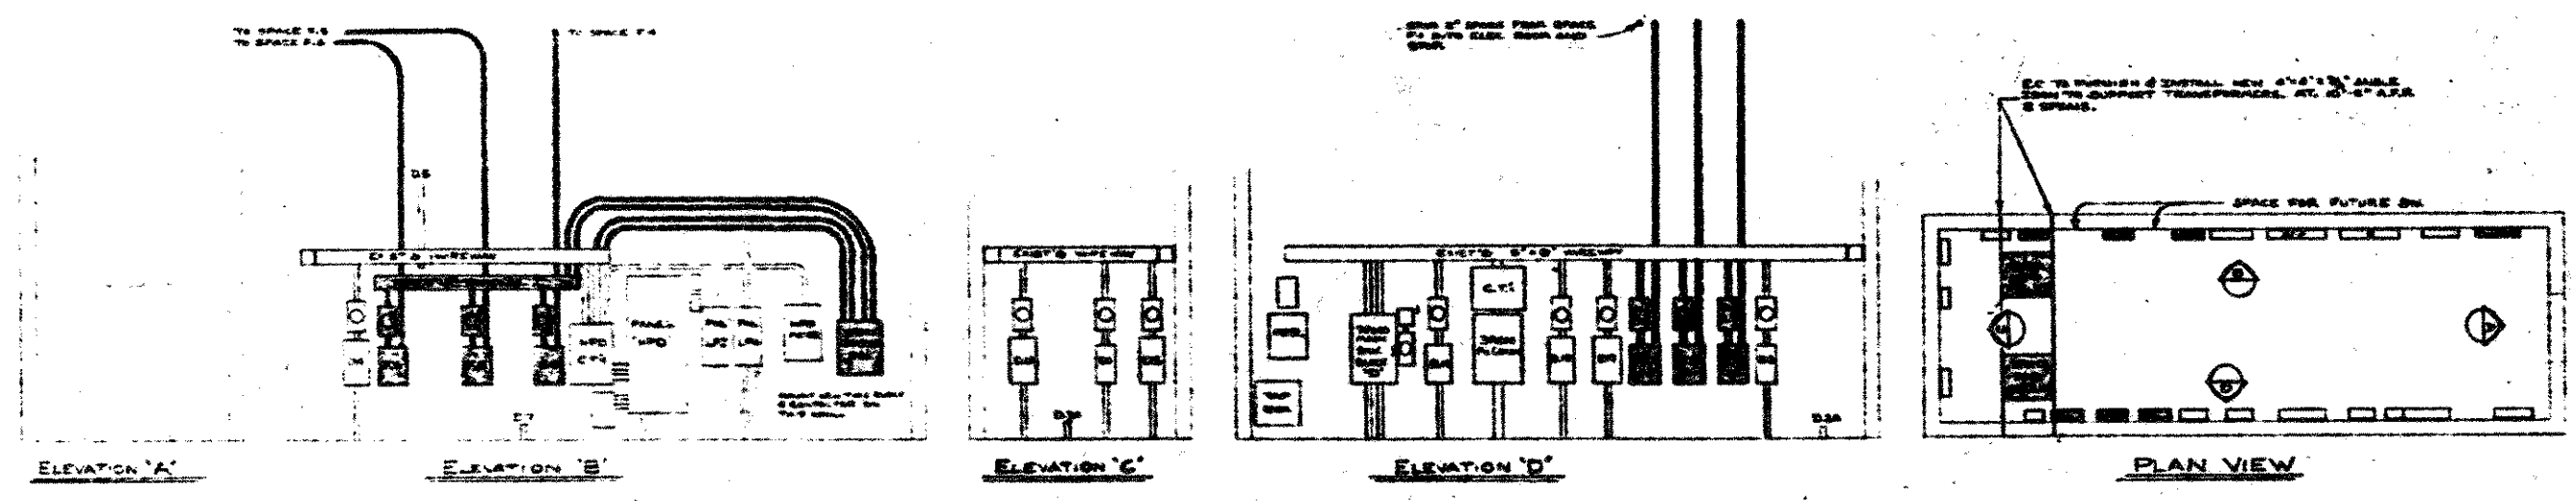

Block 'D' Electrical Room Elevations & Details
 SCALE: 1/8" = 1'-0"
 NOTE: SHADY PORTIONS DENOTES NEW EQUIPMENT.

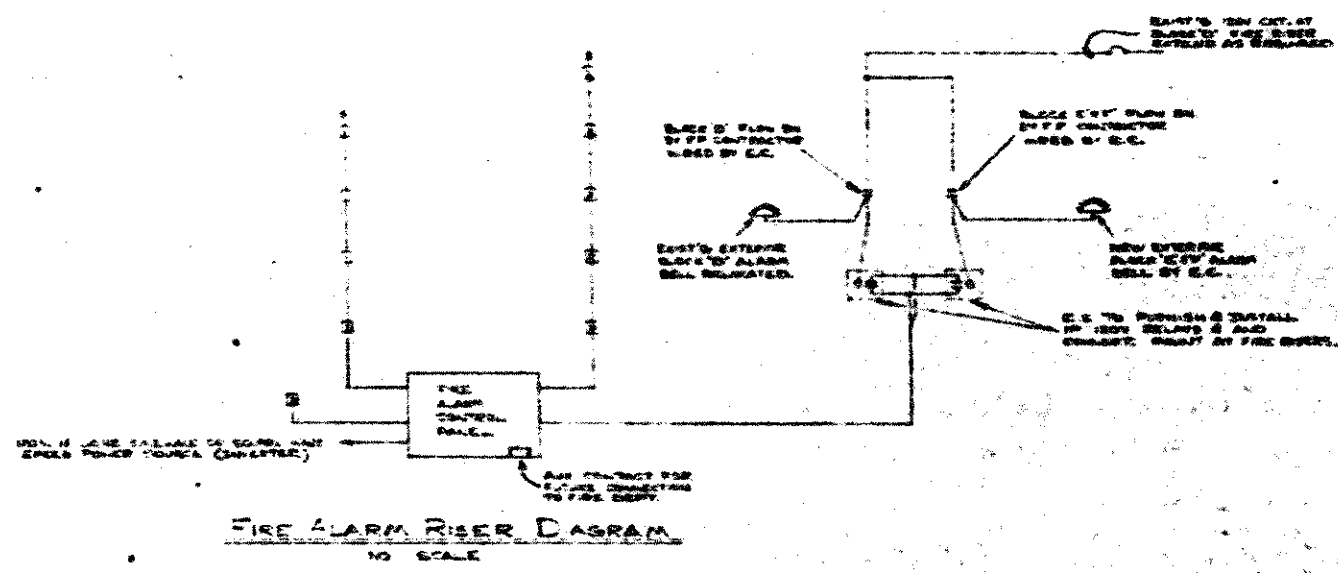

FIRE ALARM RISER DIAGRAM
 SCALE: 1/8" = 1'-0"

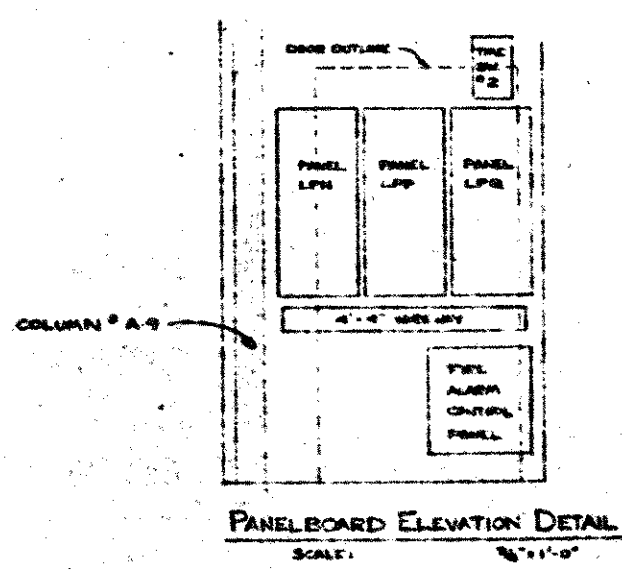

PANELBOARD ELEVATION DETAIL
 SCALE: 1/8" = 1'-0"

SHEENYK & TRALL ARCHITECTS INC. ENGINEERS, ARCHITECTS, INTERIORS, MECHANICAL, ELECTRICAL, PLUMBING, AND PAPER ENGINEERS
 35 LAKEVIEW NE, GRAND RAPIDS, MICHIGAN 49503
 CONCORD MALL
 GRAND RAPIDS, MICHIGAN
 ELECTRICAL ROOM DETAILS AND FIRE ALARM RISING DIAGRAM
 F4