




SCALE: 1/2" = 1'-0"

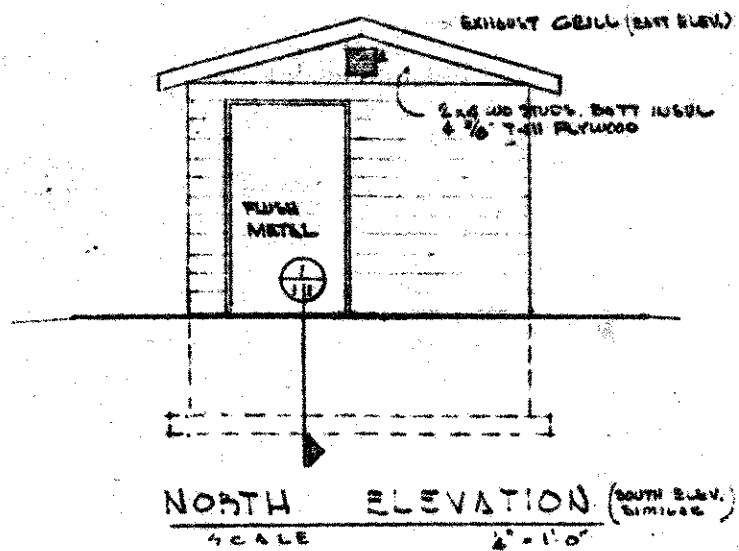


NORTH ELEVATION (SOUTH ELEV. SIMILAR)
SCALE: 1/2" = 1'-0"

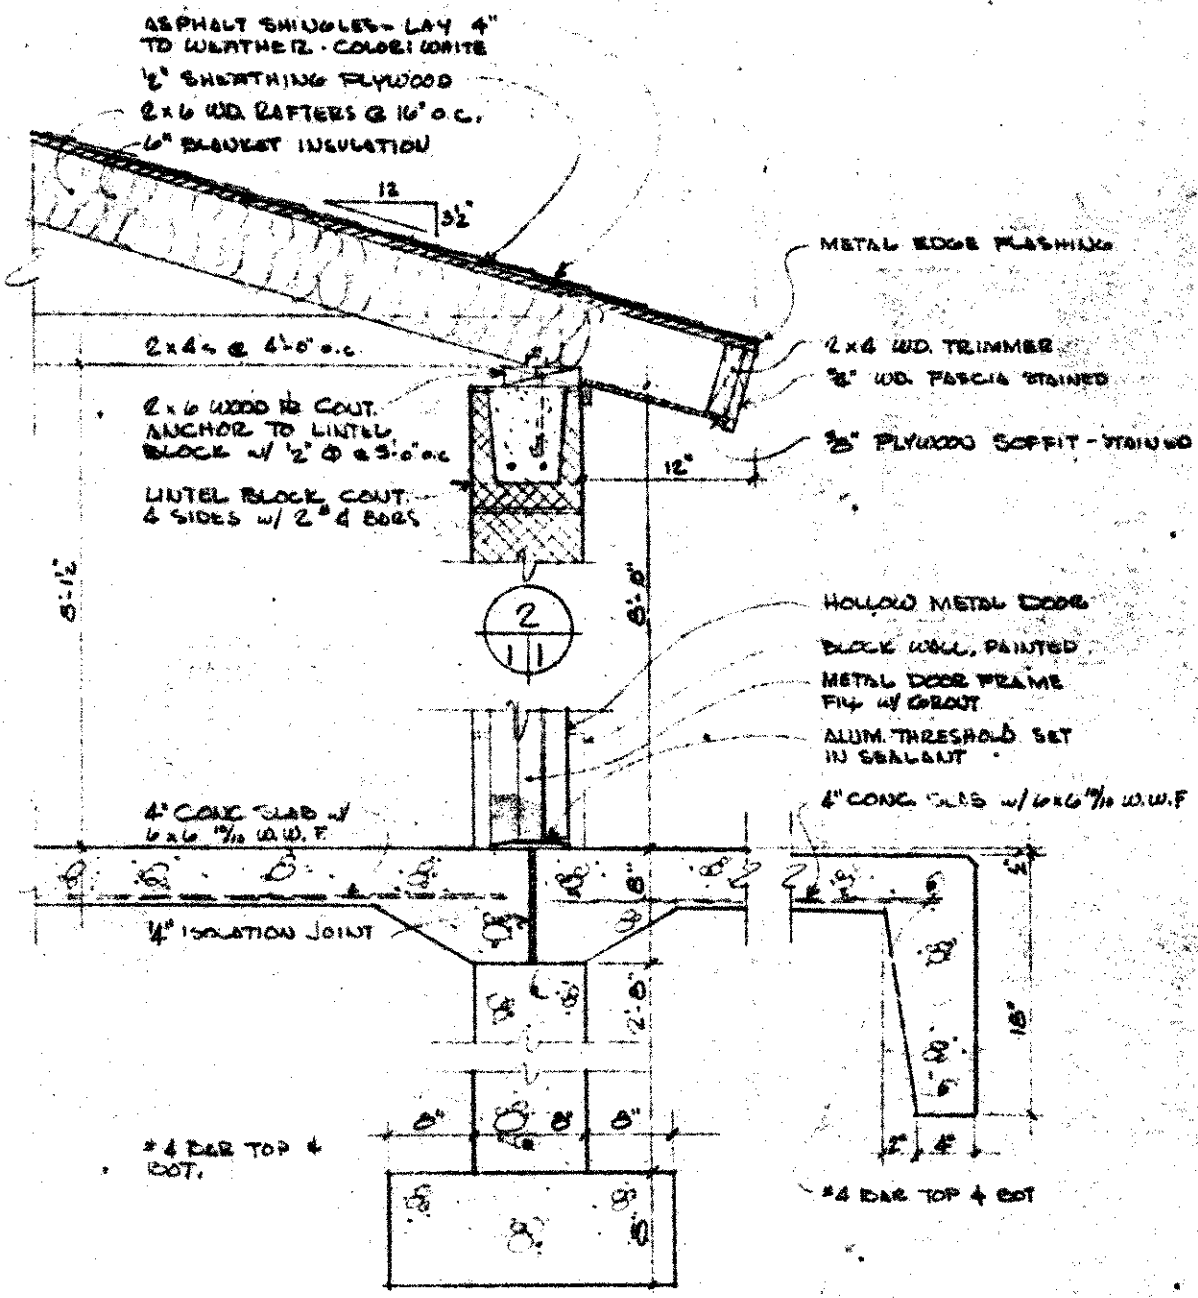

SCALE: 1/2" = 1'-0"

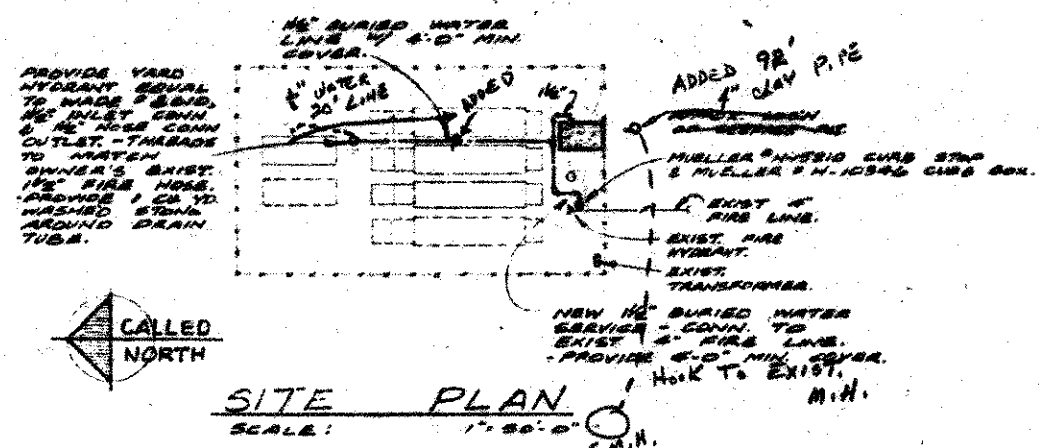


SITE PLAN
SCALE: 1" = 20'-0"

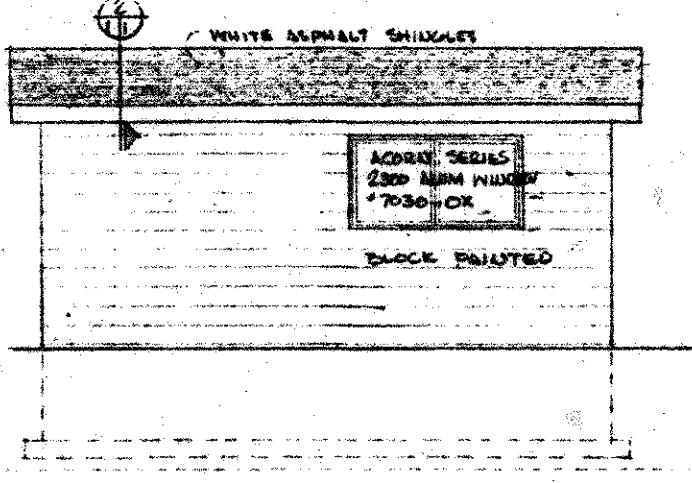


EAST ELEVATION
SCALE: 1/2" = 1'-0"


NOTE: EXIST. HIGH PRESSURE SANITARY LINE. LOCATE BEFORE & PROTECT DURING CONSTRUCTION.

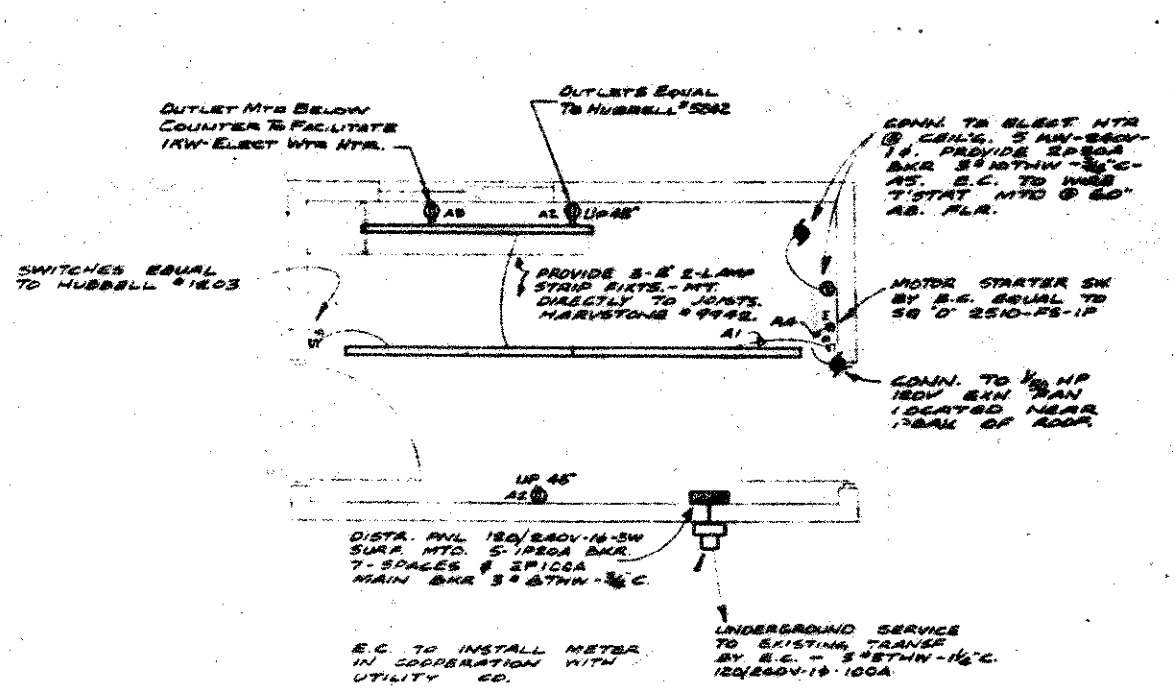

ELECTRICAL PLAN
SCALE: 1/4" = 1'-0"

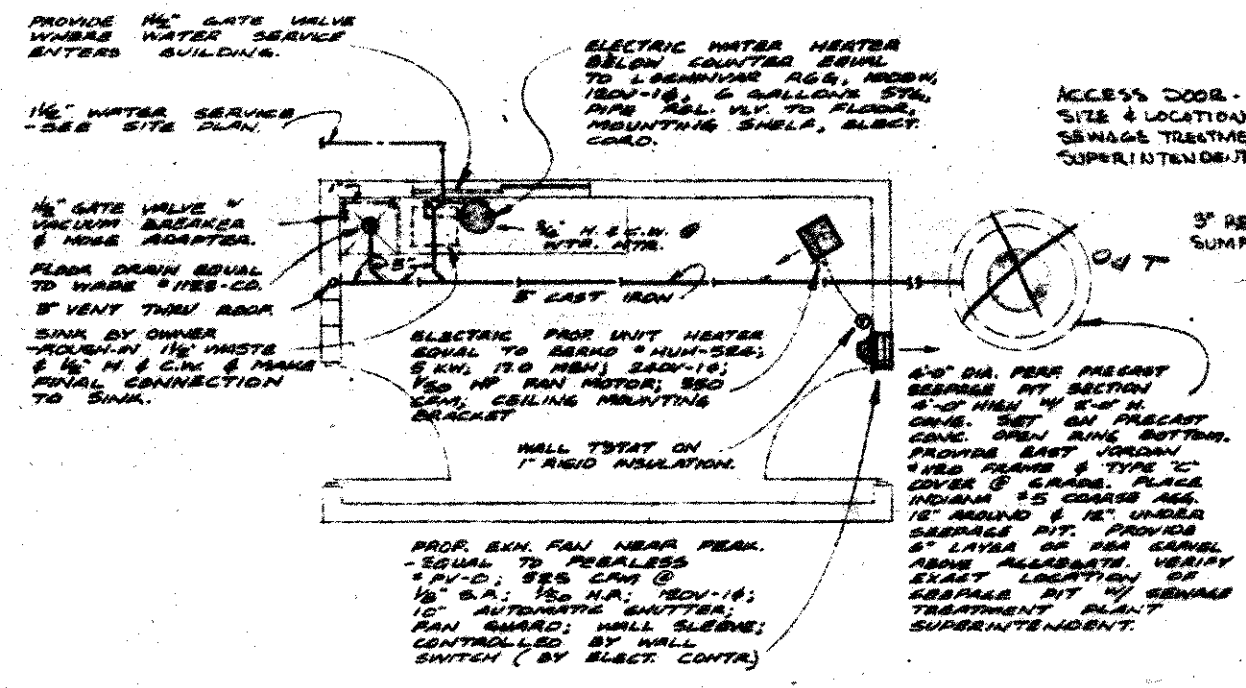

MECHANICAL PLAN
SCALE: 1/4" = 1'-0"

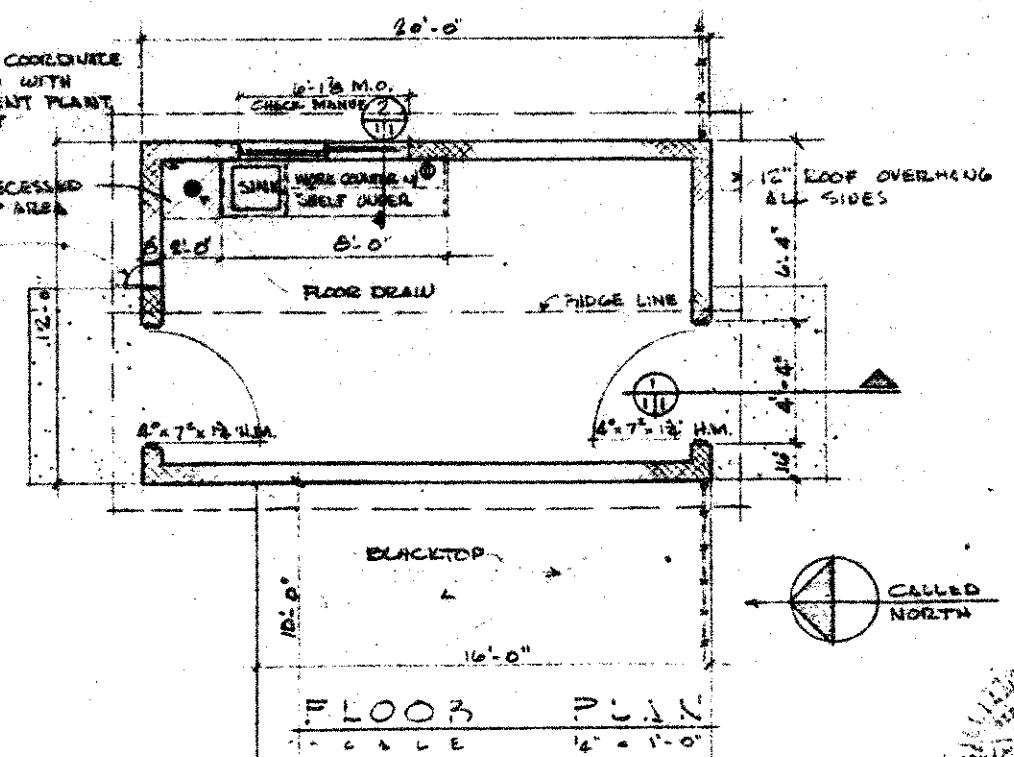

FLOOR PLAN
SCALE: 1/2" = 1'-0"

YOUR DATE
 SEWAGE TREATMENT FACILITY
 STORAGE BUILDING
 CHICAGO, ILL.
ARCHITECTS
STEENWYK · THRALL
 Standard Plans
 FILE No. 7009-1
 SHEET No. **1**