



SOUTH ELEVATION
SCALE 1/8" = 1'-0"

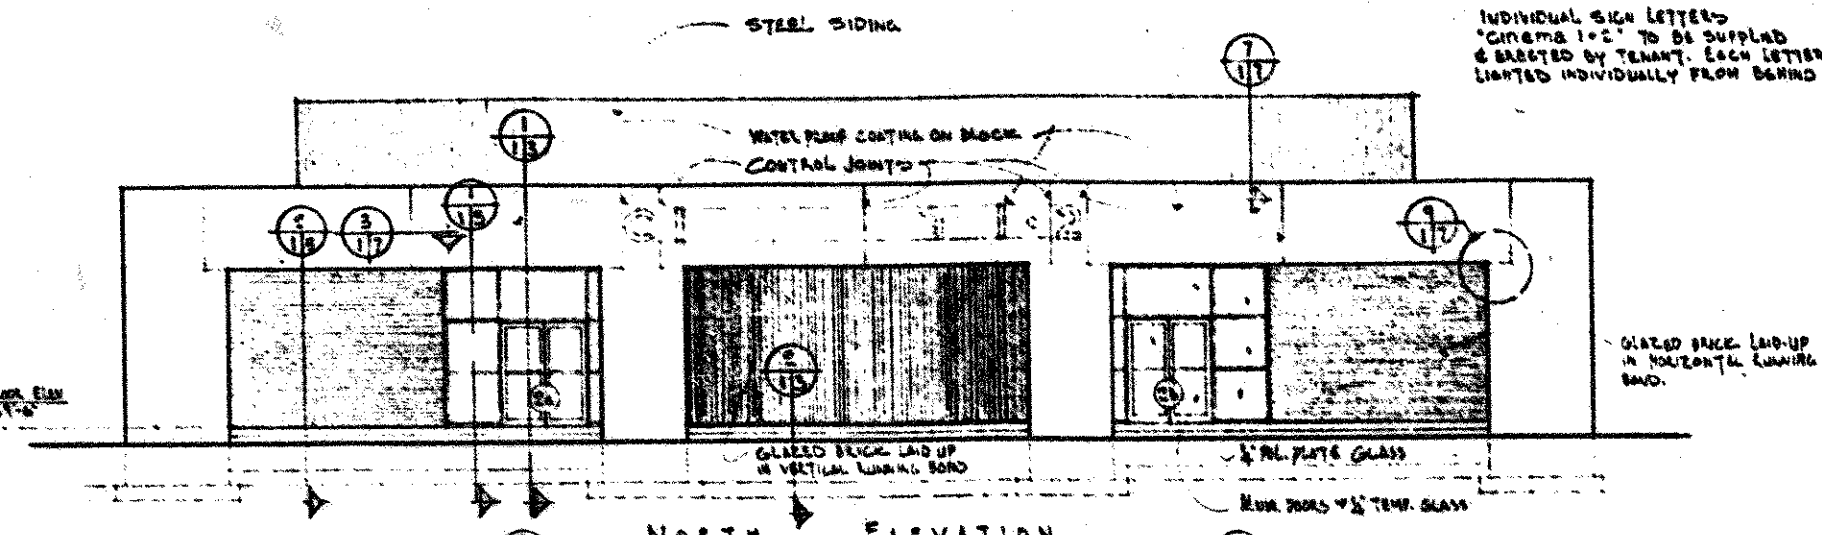


NORTH ELEVATION
SCALE 1/8" = 1'-0"

EAST ELEVATION
SCALE 1/8" = 1'-0"
(WEST ELEVATION SIMILAR BUT OPPOSITE HAND)

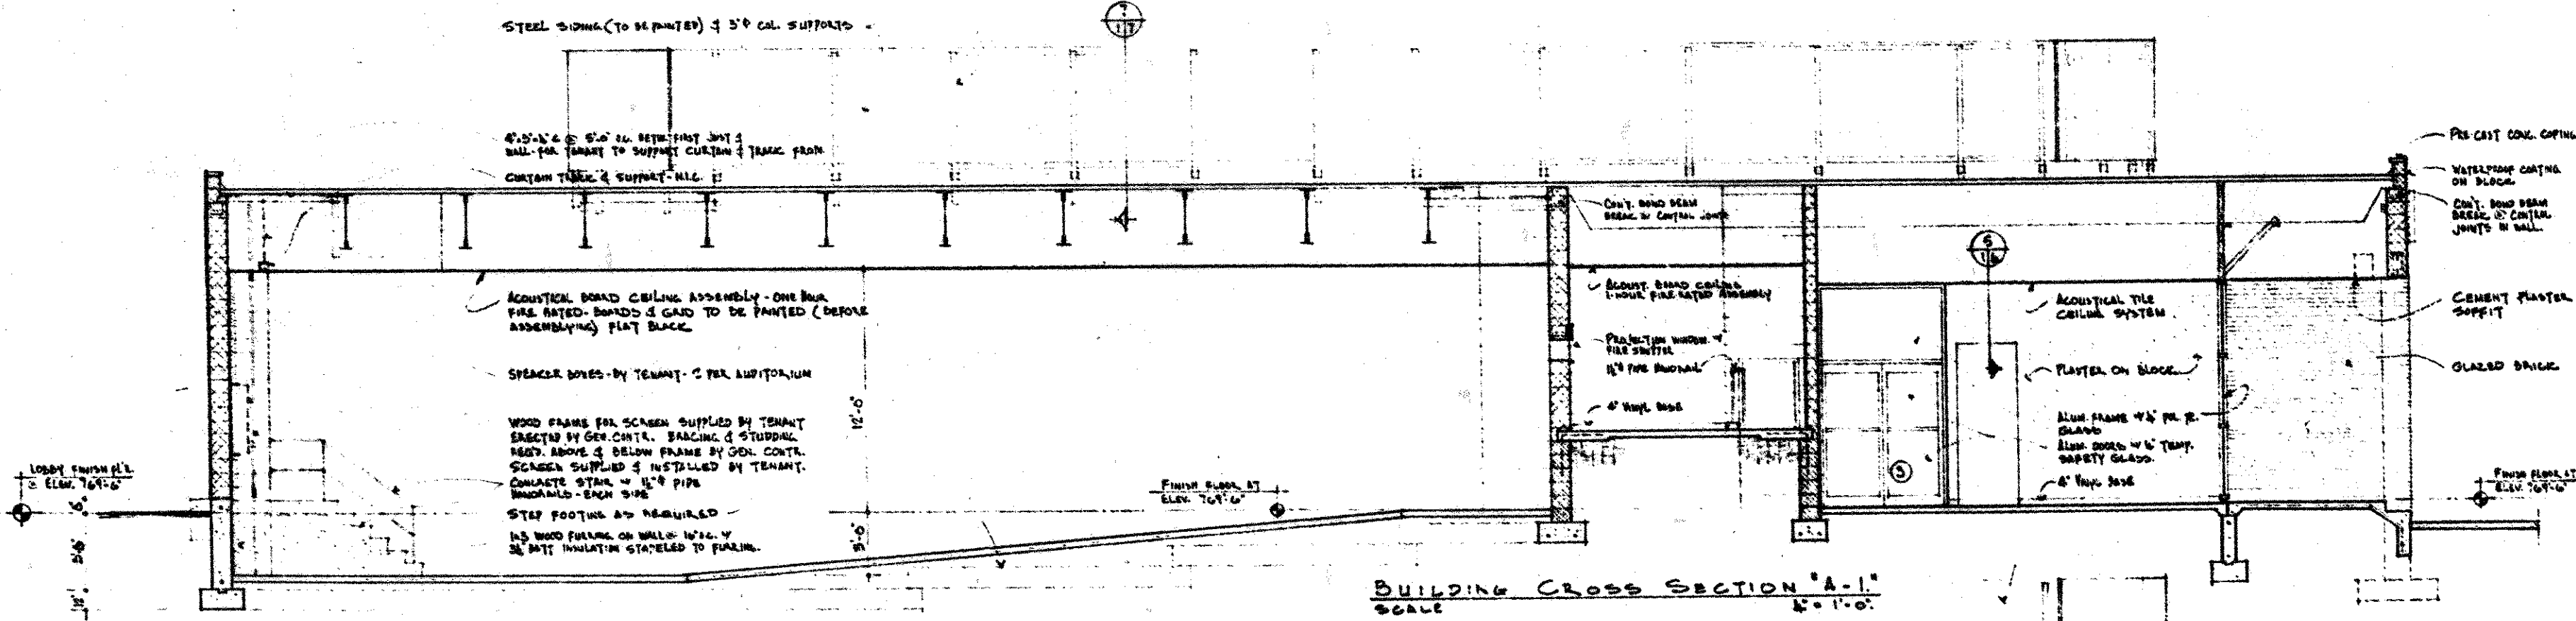

BUILDING CROSS SECTION 'A-1'
SCALE 1/8" = 1'-0"

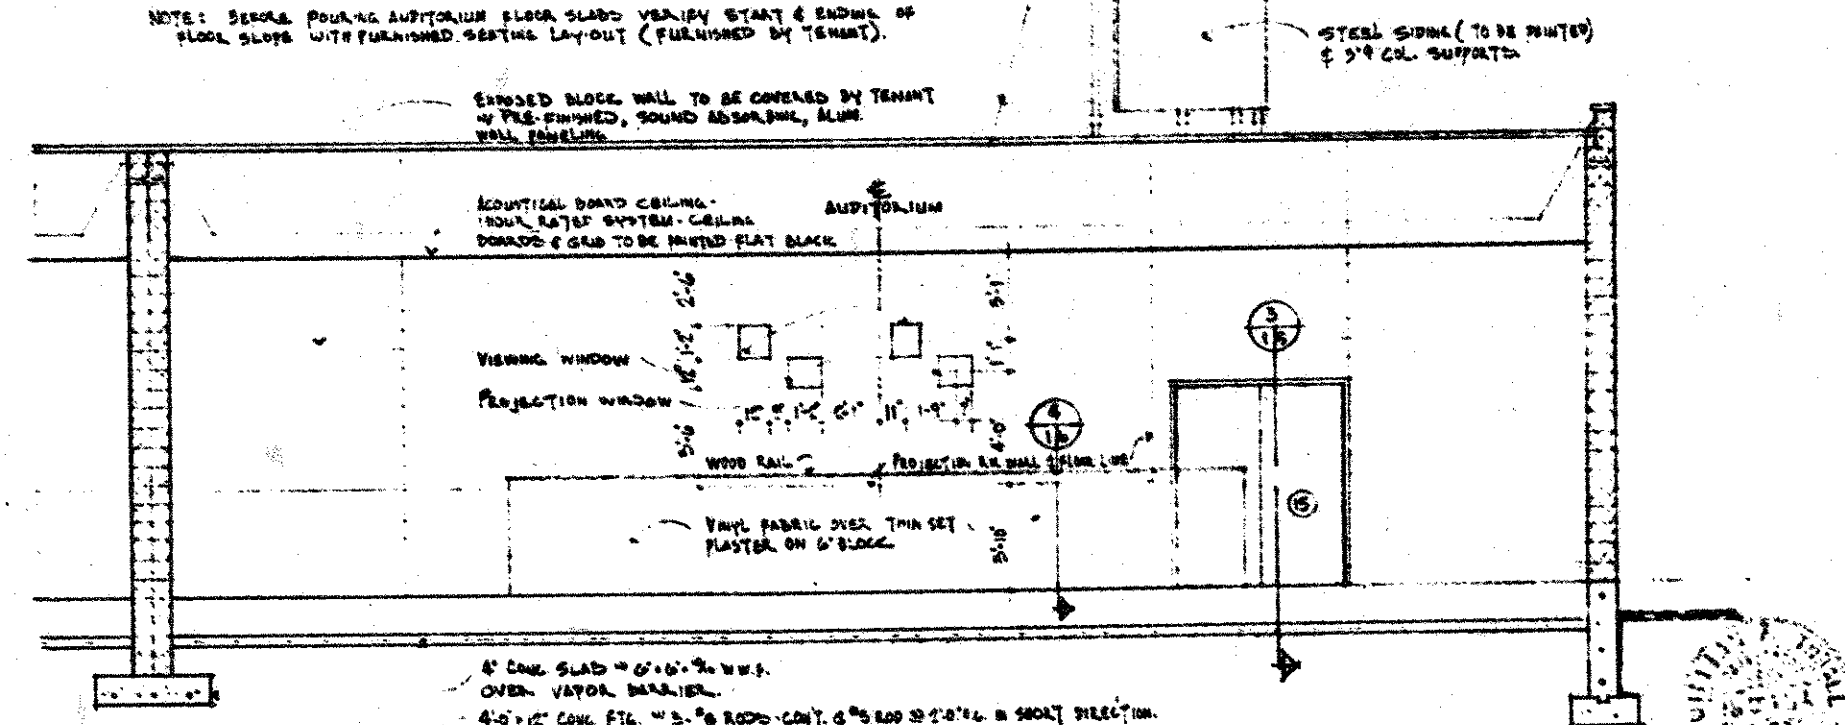

BUILDING CROSS SECTION 'B-1'
SCALE 1/8" = 1'-0"

| TABLE OF CONTENTS | |
|-------------------|--|
| SHEET NO. | SECT. TITLE |
| 1 | EXTERIOR ELEVATIONS & BUILDING CROSS SECTIONS. |
| 2 | FLOOR PLANS & SCHEDULES. |
| 3 | BUILDING SECTIONS. |
| 4 | BUILDING PLAN SECTIONS. |
| 5 | BUILDING SECTIONS. |
| 6 | BUILDING SECTIONS. |
| 7 | MISC. BUILDING SECTIONS & DETAILS. |
| 8 | ROOF PLAN, REFLECTED CEILING PLAN & DETAILS. |
| 9 | FOUNDATION & ROOF FRAMING PLANS. |
| M-1 | PLUMBING FLOOR PLAN & DETAILS. |
| M-2 | H.V.A.C. FLOOR PLAN & DETAILS. |
| M-3 | H.V.A.C. SCHEDULES & MISCELLANEOUS DETAILS. |
| E-1 | ELECTRICAL FLOOR PLAN - LIGHTING & LEGENDS. |
| E-2 | ELECTRICAL FLOOR PLAN - POWER & DIAGRAMS. |

INDIVIDUAL SIGN LETTERS
"CINEMA" TO BE SUPPLIED
& SET BY TENANT. EACH LETTER
LIGHTED INDIVIDUALLY FROM BEHIND

DATE MOVED
JUNE, 1972
DECEMBER, 1972

TWIN CINEMA
CONCORD MALL
ELKHART INDIANA

STENWYK - TRALL ARCHITECTS
REGISTERED ARCHITECTS

FILE NO.
7009-4

SHEET NO.

1