


Mark	TYPE	MANUFACTURER & CAT. NO.	LAMPS
A	Recessed Wallwash	Progressive #1055-1028 (100W-4000)	175W-R40
B	Recessed Round	Progressive #79-084	175W-R50
C	Spot Flood	Progressive #1055-1028 (100W-4000)	175W-R40
D	Recessed Lamp	Progressive #1055-1028 (100W-4000)	175W-R40
E	Recessed Island	Progressive #1055-1028 (100W-4000)	175W-R40
F	Spot Flood	Progressive #1055-1028 (100W-4000)	175W-R40
G	Spot Flood	Progressive #1055-1028 (100W-4000)	175W-R40
H	Recessed Island	Progressive #1055-1028 (100W-4000)	175W-R40
J	Emergency Lts	Dual Lite #EXT-100 (500mA/100W)	2x 100W
K	Emergency Lts	Dual Lite #EXT-100 (500mA/100W)	2x 100W
L	Recessed Square	Progressive #1015-017	175W-Yellow
M	Recessed Round	Progressive #1055-100	100W-4000
N	Recessed Round	Progressive #1055-100	100W-4000
O	Spot To Lamp	Architectural Area Lighting #1055-100	175W-CLEAR
P	Decorative Fixt.	Form by Onuma & Small Exposed #1055-100	175W-CLEAR
Q	Wall Mtg. Head	Art Metal #1055-100	175W-0736

Mark	DESCRIPTION	NOTES
1	Single Pole Switch	100W-1000
2	Double Pole Switch	100W-1000
3	Control Panel	100W-1000
4	Transformer	100W-1000
5	Emergency Battery	100W-1000
6	Emergency Battery	100W-1000
7	Emergency Battery	100W-1000
8	Emergency Battery	100W-1000
9	Emergency Battery	100W-1000
10	Emergency Battery	100W-1000
11	Emergency Battery	100W-1000
12	Emergency Battery	100W-1000
13	Emergency Battery	100W-1000
14	Emergency Battery	100W-1000
15	Emergency Battery	100W-1000
16	Emergency Battery	100W-1000
17	Emergency Battery	100W-1000
18	Emergency Battery	100W-1000
19	Emergency Battery	100W-1000
20	Emergency Battery	100W-1000

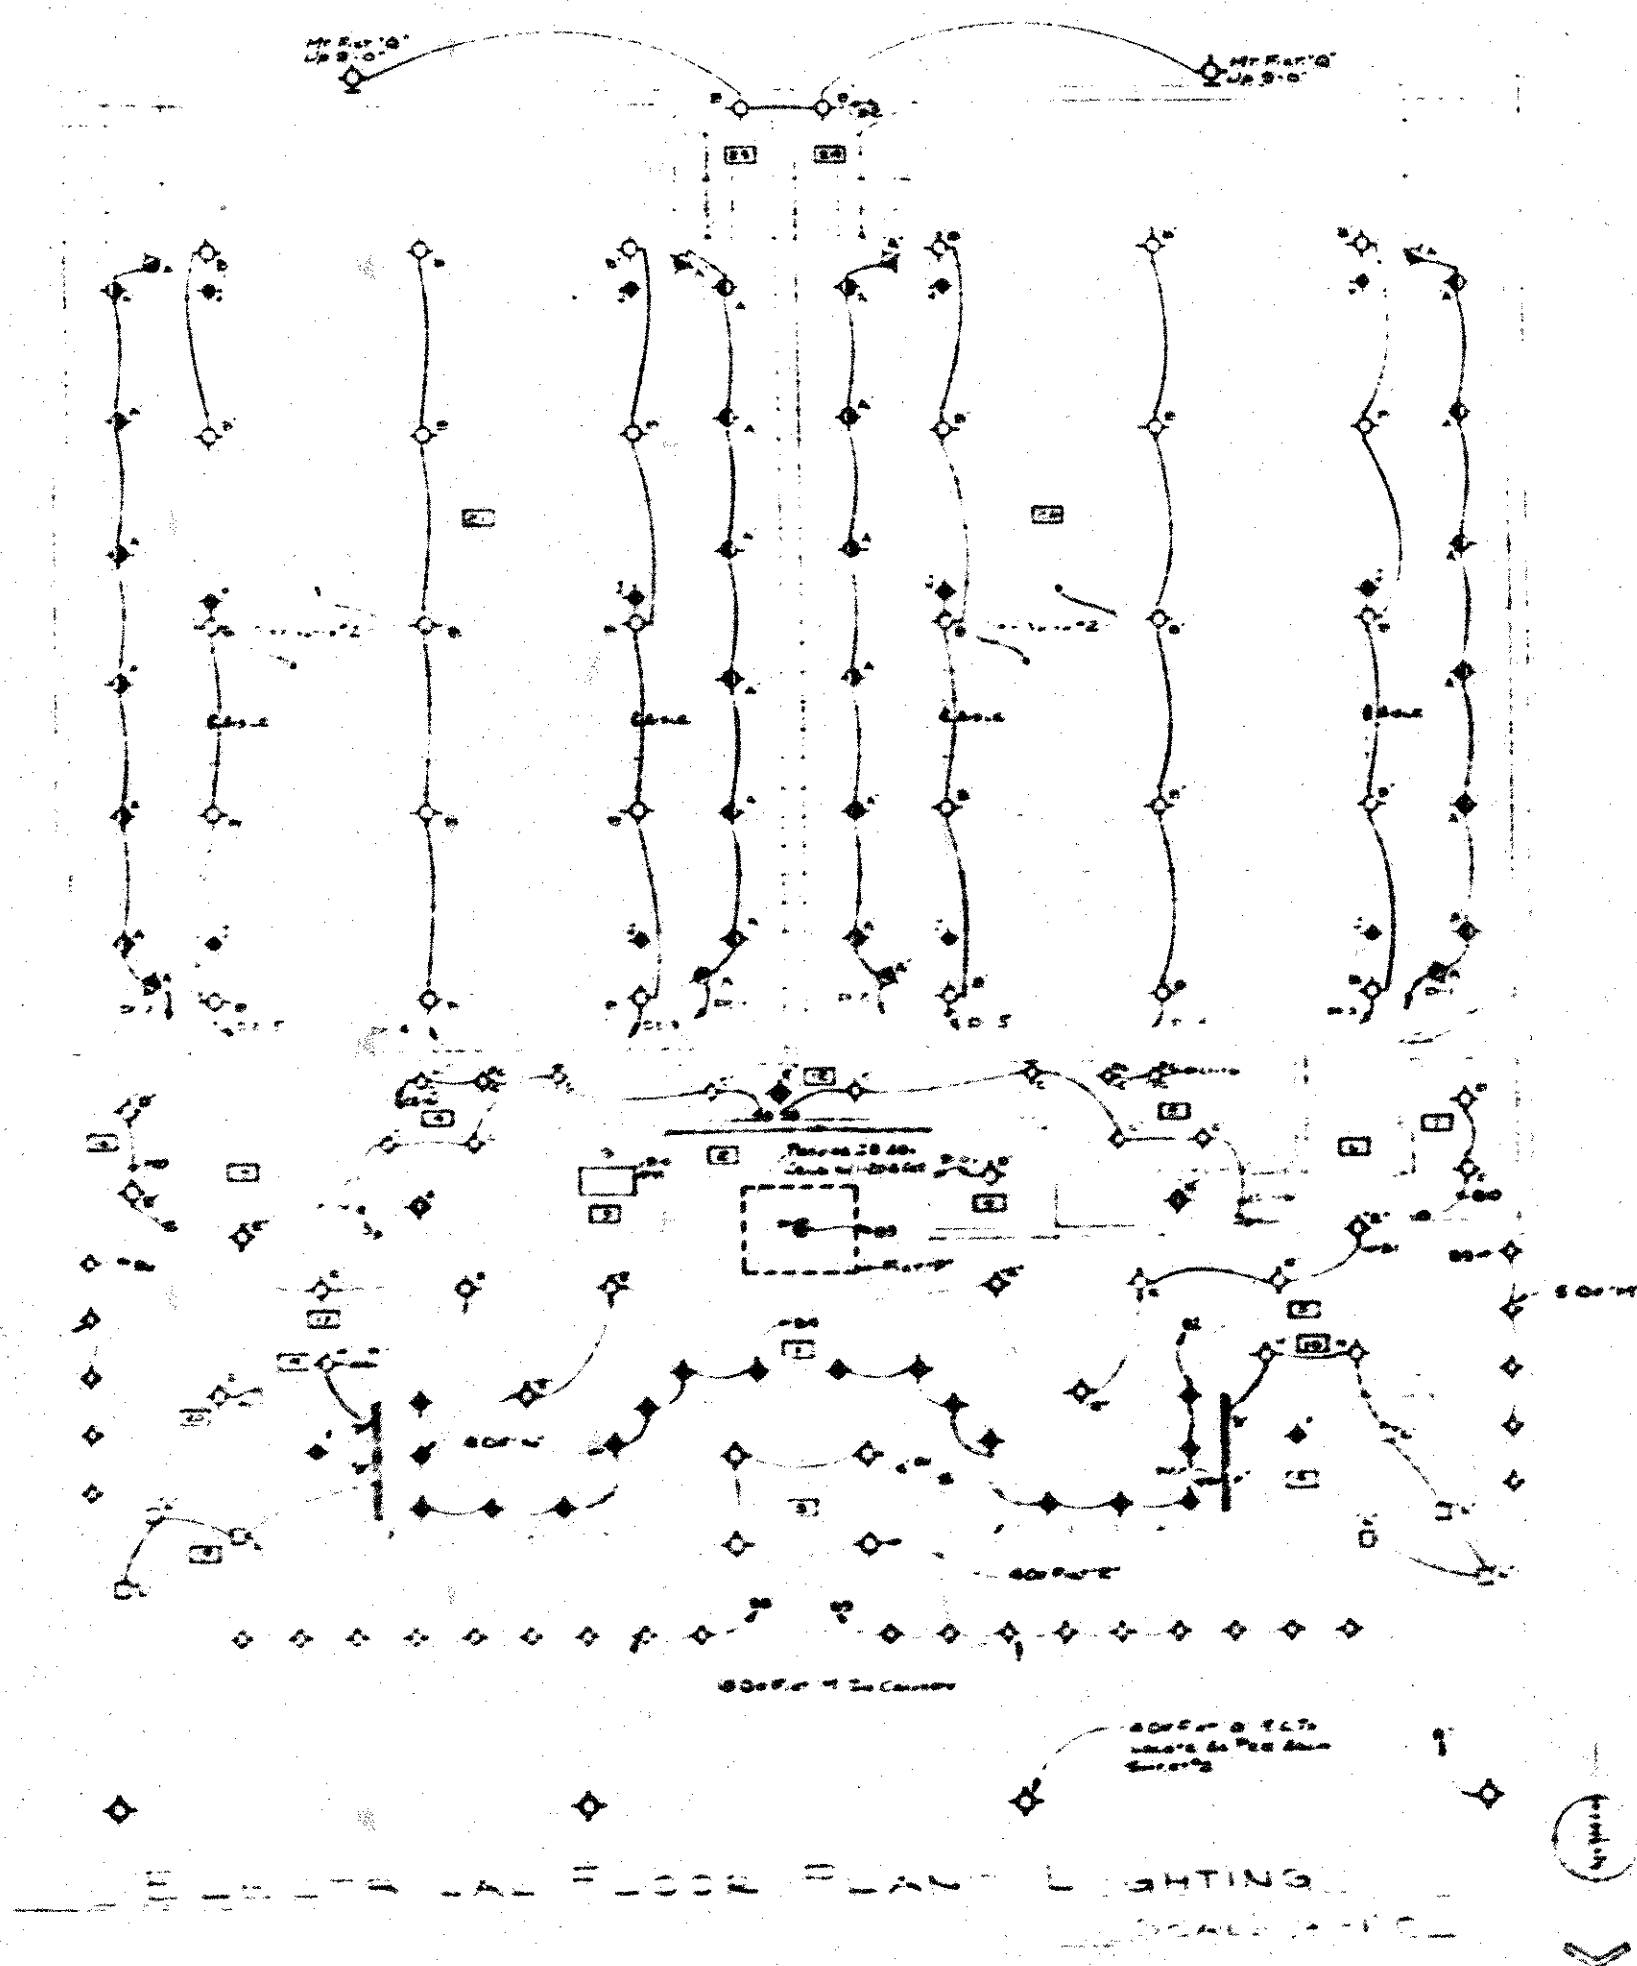

THEATER FLOOR PLAN LIGHTING

SCALE: 1/8" = 1'-0"

NOTES:

1. All lights to be installed in accordance with the manufacturer's instructions.
2. All lights to be installed in accordance with the manufacturer's instructions.
3. Refer to the manufacturer's instructions for the correct installation of the lights.

**TWIN CINEMA**  
 PROGRESSIVE ENGINEERING CONSULTANTS  
 OF GRAND RAPIDS, MICHIGAN, INC.  
 GRAND RAPIDS, MICHIGAN - 49503-8800

**STENWYK • THRALL ARCHITECTS**  
 GRAND RAPIDS, MICHIGAN