



NOTE: DETAILS FOR Rm. 5, Rm. 4 TO BE SIMILAR.
 REFER TO PLAN PROJECTION ROOM ROOM 20 PLANS FOR FULL REQUIRE.

PROJECTION ROOM DETAIL
 SCALE 3/8" = 1'-0"

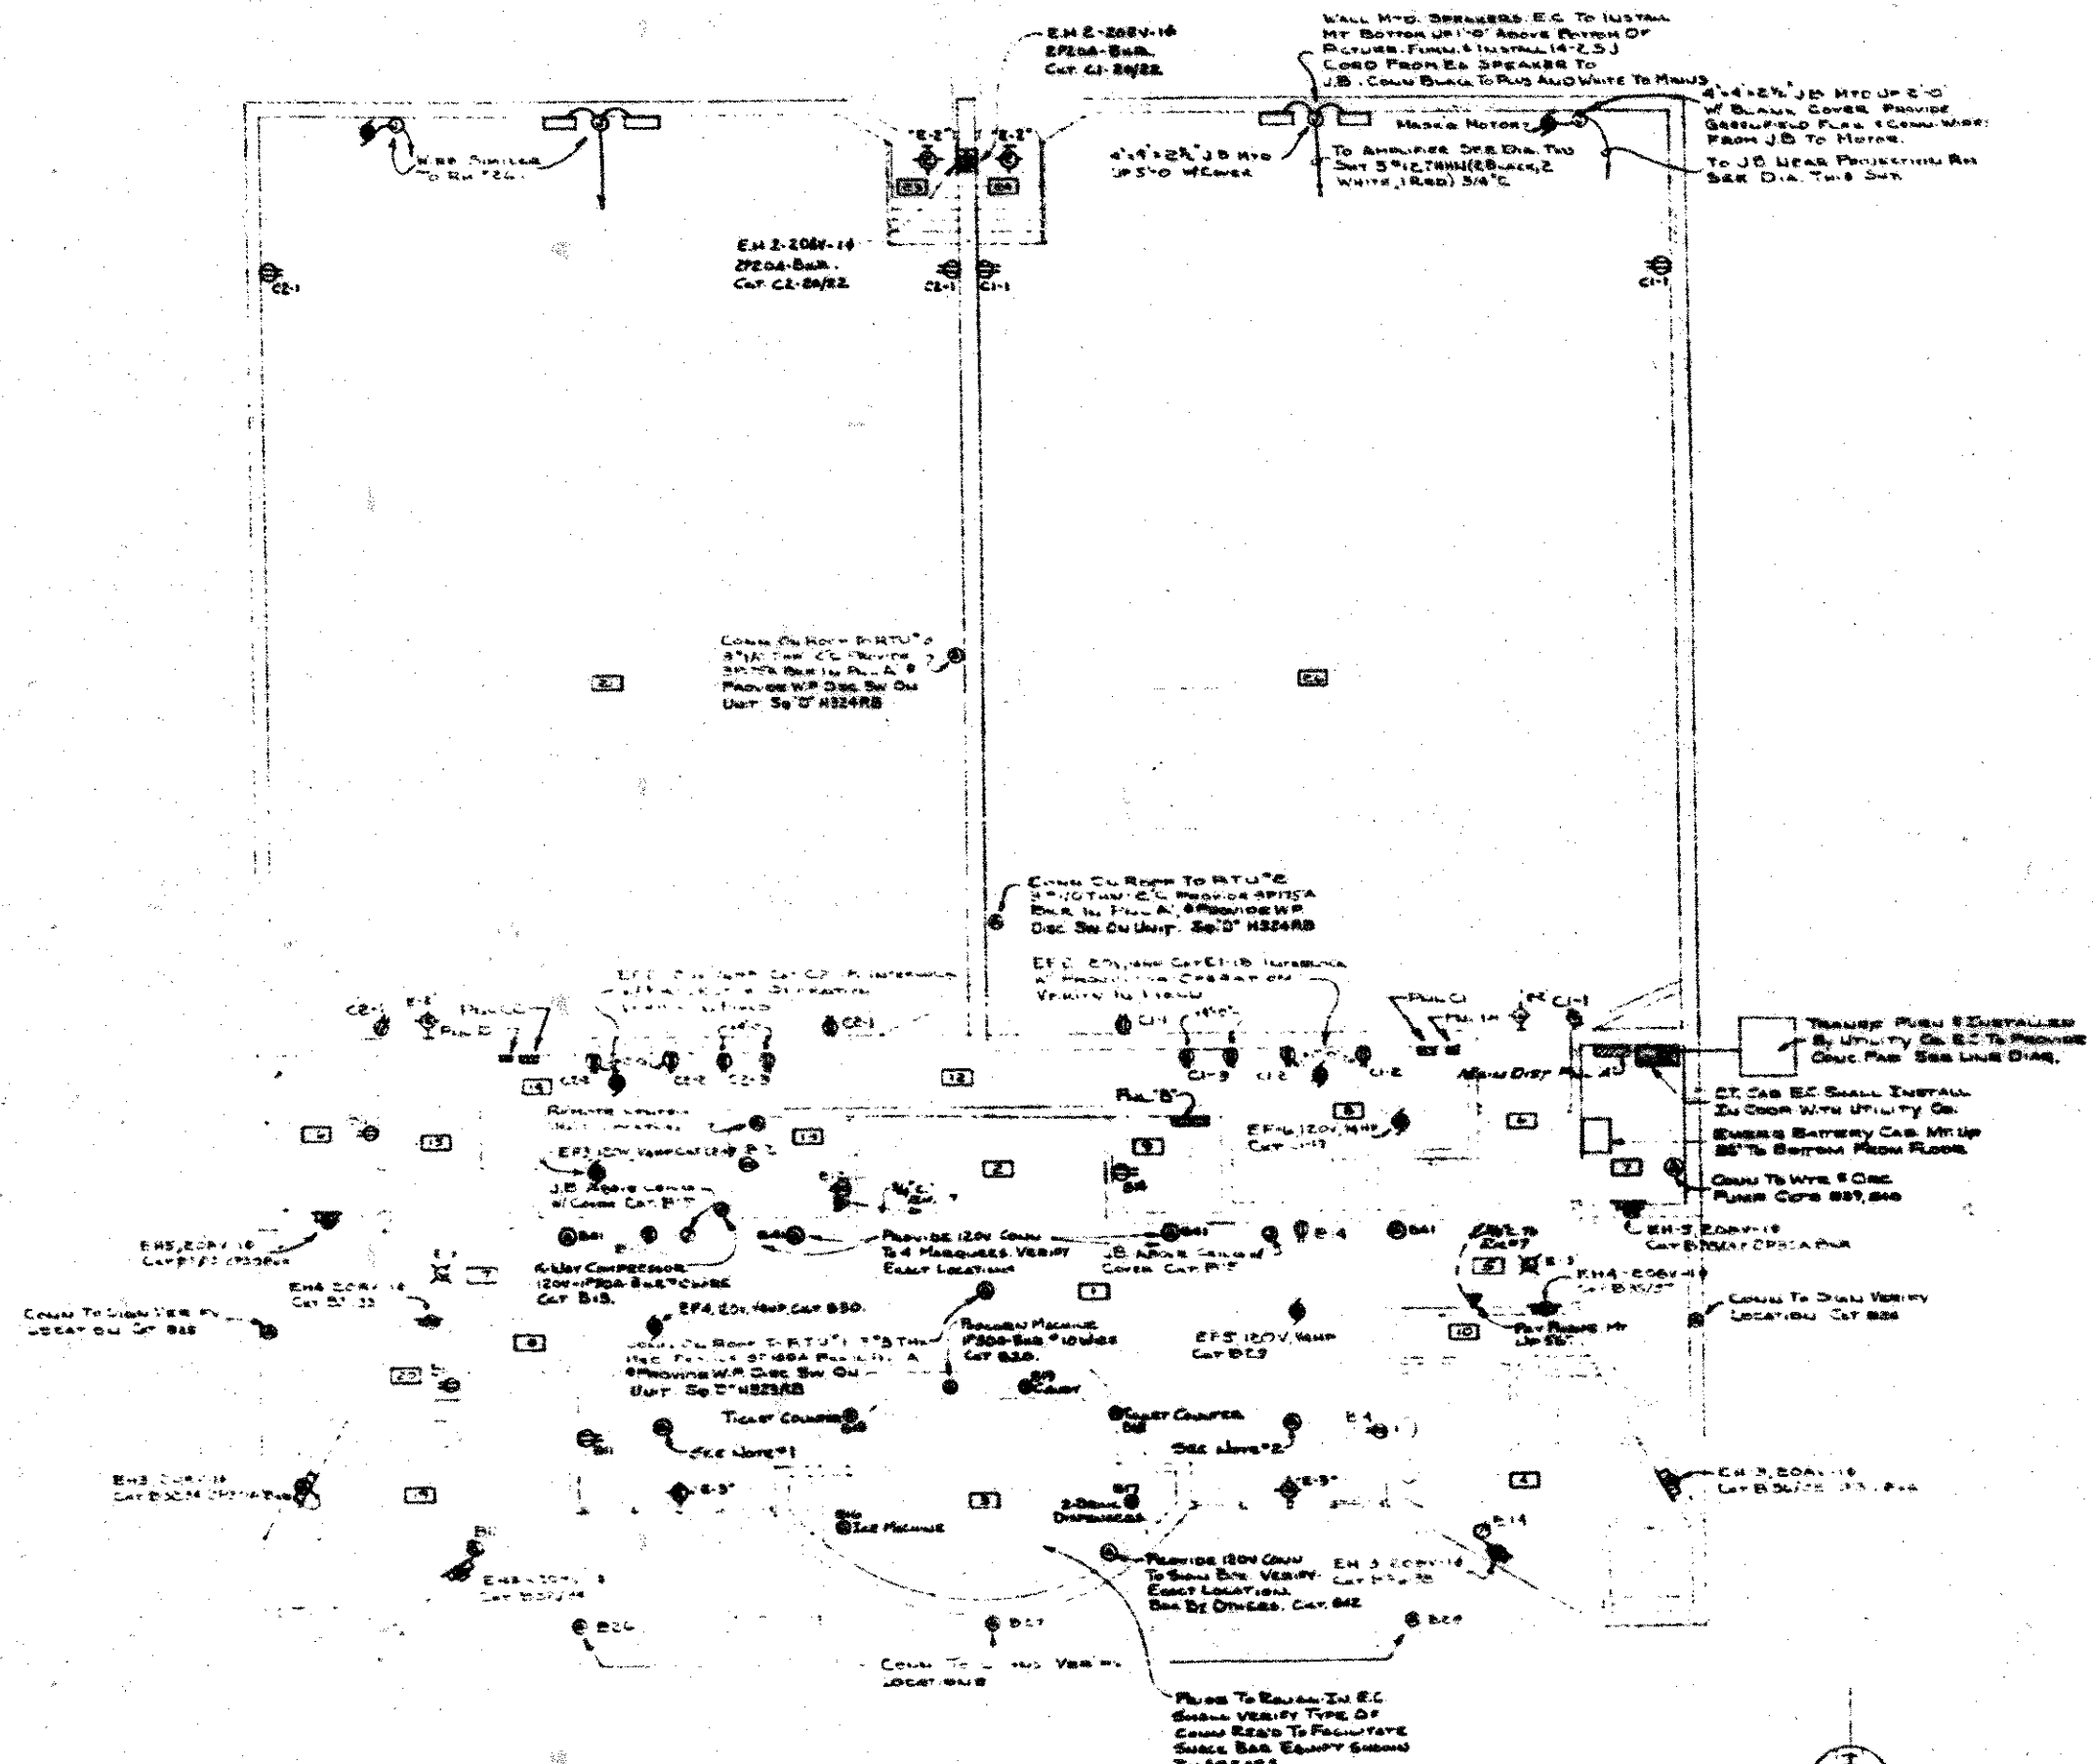

ELECTRICAL FLOOR PLAN - POWER
 SCALE 1/8" = 1'-0"

NOTES
 1. EM 2-200V-10 2P20A-BRM. IN PLAN "A"
 2P20A-3/4" REVERSE FUSED DIS. E. UNIT
 SA D 112222.
 2. RM-C1 - SEE JUVENI-DANE.

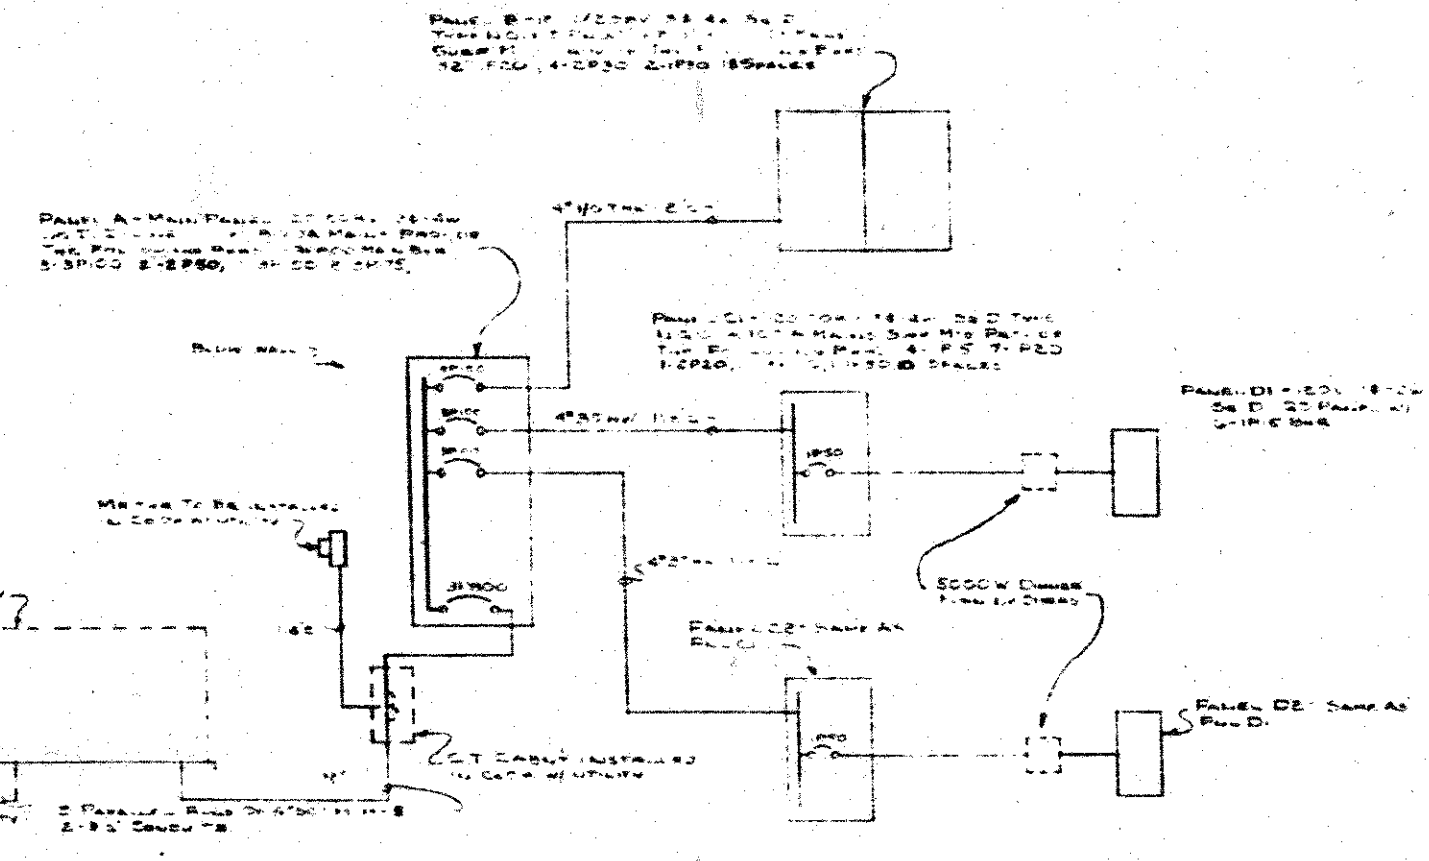

120/208V-3P-4W ONE LINE DIAGRAM
 NO SCALE