



SYMBOL LEGEND			
SYM.	DESCRIPTION	MTG. HT.	REMARKS
⊕	DUPLEX RECEPTACLE - HUBBELL #2662 W/ BROWN COVER PLATE	18"	
⊙	FLOOR OUTLET - HUBBELL #2637/2375E/2662		
▽	TRANSFORMER		
⊞	DISCONNECT SWITCH	7 1/2' TO TOP	
⊞	120/208 3P 4W PANEL	7 1/2' TO TOP	
S	SINGLE-POLE SWITCH - ARROW HART #1101	36"	
⊞	COMBINATION LIGHT (FAN - NUTONE #8662)		PROVIDED BY ELEC. CONTRACTOR
△	TELEPHONE FLOOR OUTLET - HUBBELL #2637/2662		PROVIDE 3/4" C. FROM EACH OUTLET TO TELE. PNL
⊞	TELEPHONE WIRING BOX W/ HUBBELL #9181 COVER PLATE	18"	PROVIDE 3/4" C. FROM EACH BOX TO TELE. PNL
⊞	EXIT SIGN - ART METAL #E-6W-1		MT. 9" ABOVE DOOR FRAME
---	WIRING IN CEILING OR WALLS - CROSS MARKS INDICATE NO. OF CONDUCTORS. LONGER MARKS INDICATE NEUTRALE		ALL CONDUCTORS W/ 1/2" UNLESS OTHERWISE INDICATED.
---	WIRING IN FLOOR		
⊕	NUMBER NEXT TO DEVICE INDICATES CRT. NUMBER		

NOTE:
MOUNTING HEIGHTS ARE TO CENTER LINE UNLESS OTHERWISE INDICATED.

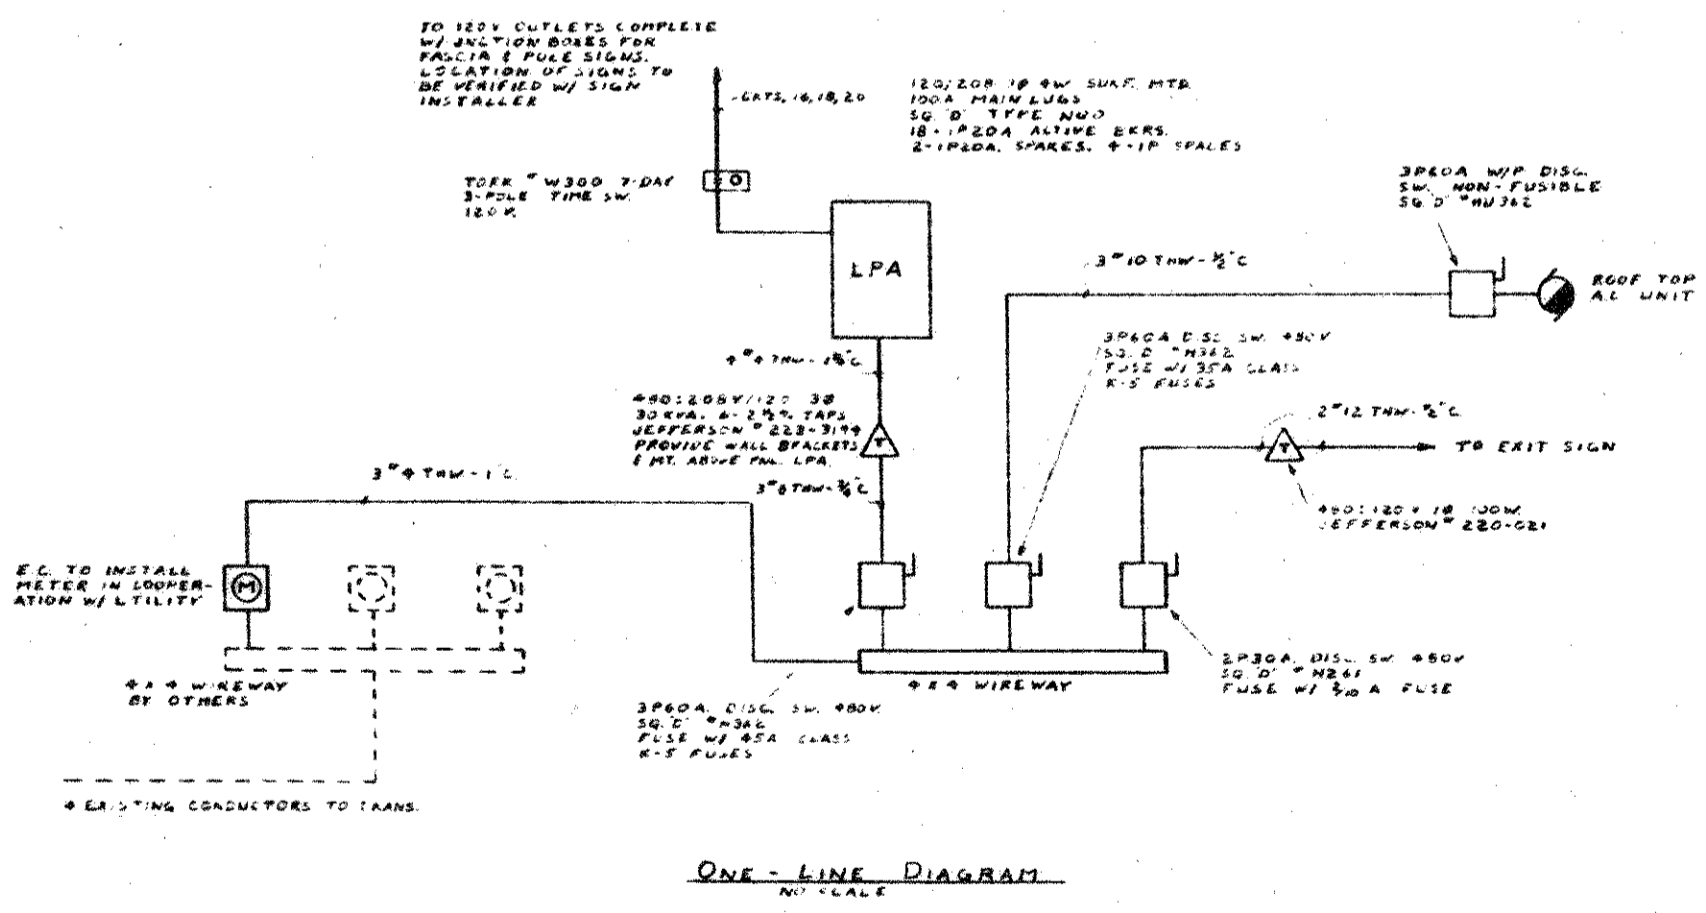

TELEPHONE PNL
42" X 36" ALUMWOOD
PROVIDE OUTLET FOR
TELE. EQUIP

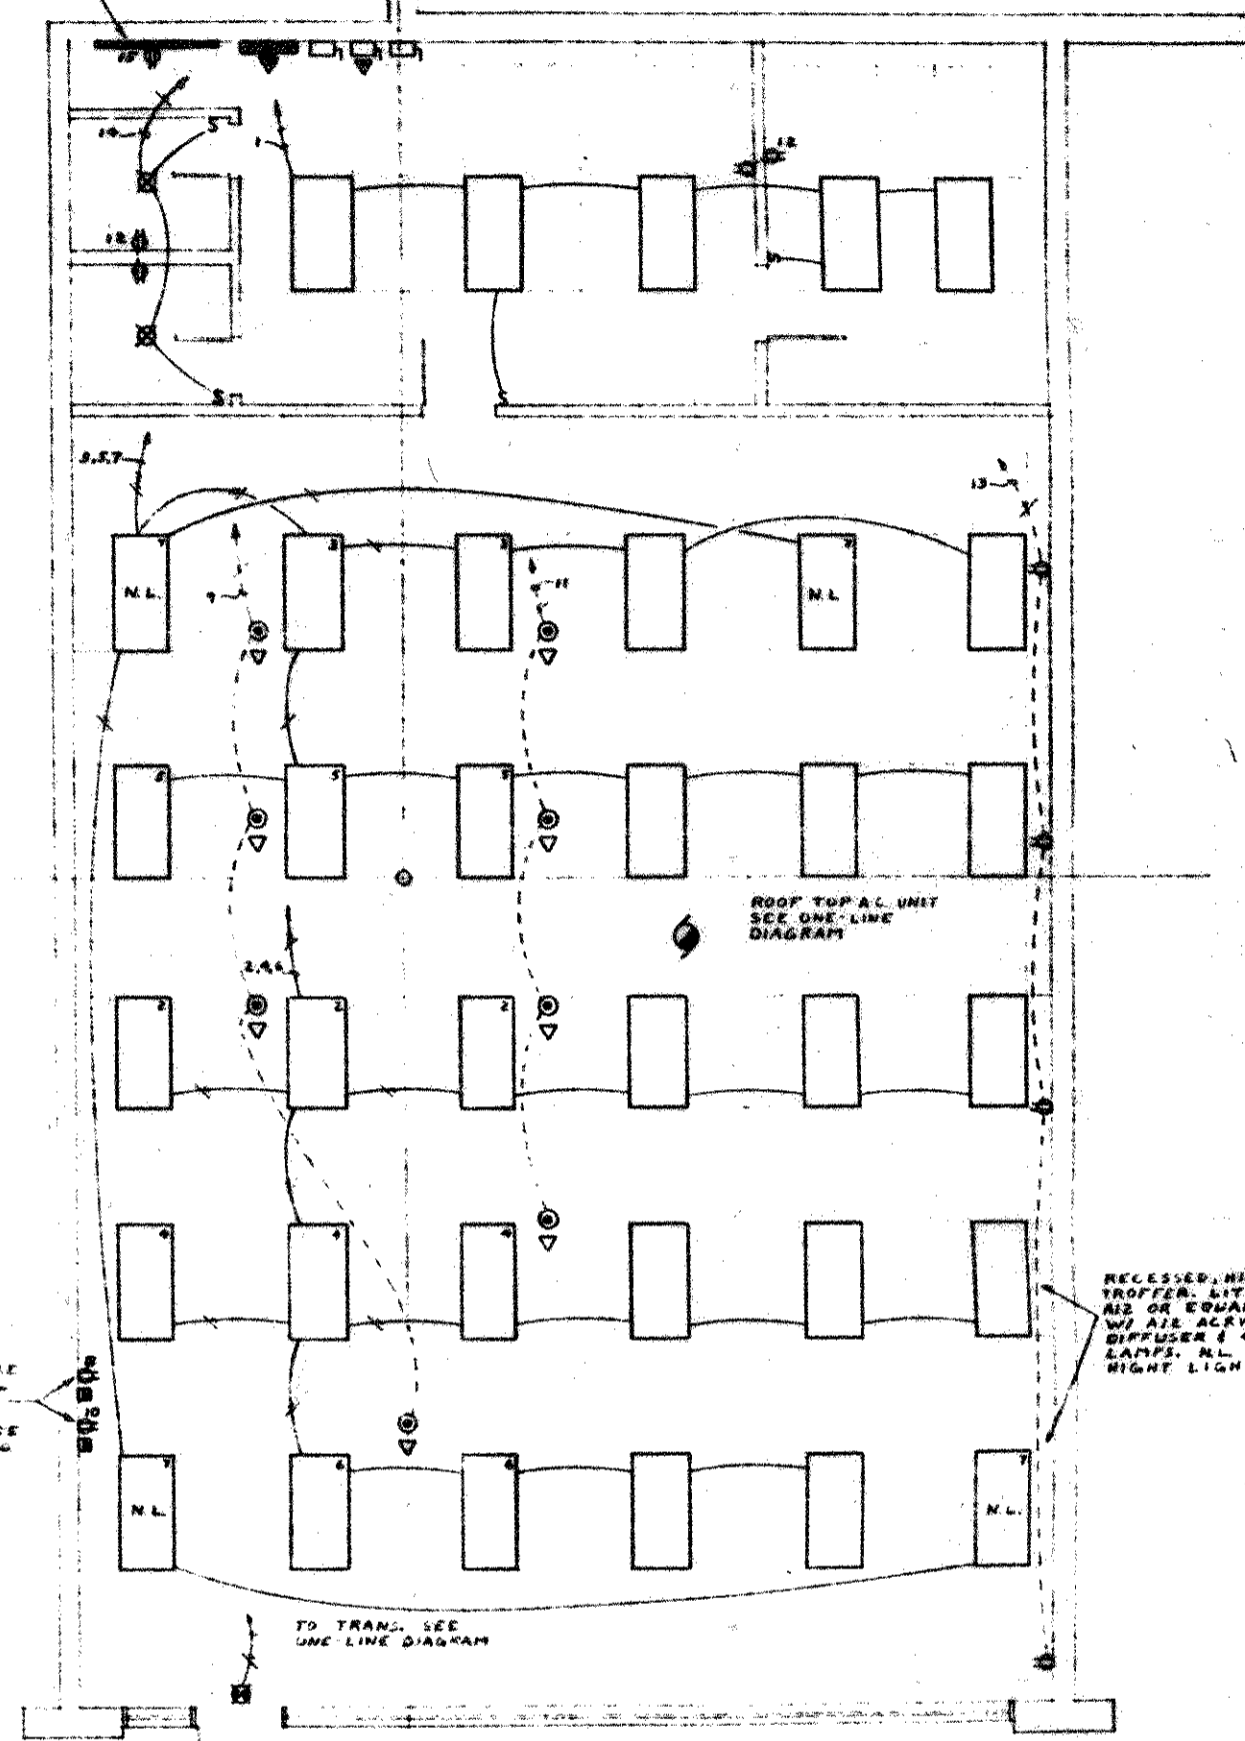

ELECTRICAL FLOOR PLAN
SCALE: 1/4" = 1'-0"

ISSUE DATE
11-10-75

AVCO FINANCIAL SERVICES
CONCORD MALL
ANNEX
ELKHART INDIANA

FILE NO.
7410-25

SHEET NO.
1

