


**MECHANICAL LEGEND**

C.W.	COLD WATER
H.W.	HOT WATER
W.	WASTE
S.W.	SEWER
S.C.	STEAM CONDENSE
S.C.	STEAM CONDENSE
V.	VENT
V.T.	VENT THROUGH ROOF
S.C.	SEWER OUT
A.F.F.	ABOVE FINISH FLOOR
S.A.D.	SUPPLY AIR DIFFUSER
E.V.A.U.	EXHAUST AIR DIFFUSER
S.A.C.	SUPPLY AIR CELLS
E.A.	EXHAUST AIR
P.D.	PIPE DRAINAGE
A.H.U.	AIR HANDLING UNIT
E.C.U.	EXHAUST UNIT
E.C.C.	ELECTRIC CONTROL CELL
T.E.G.	TELEPHONE GALLEY

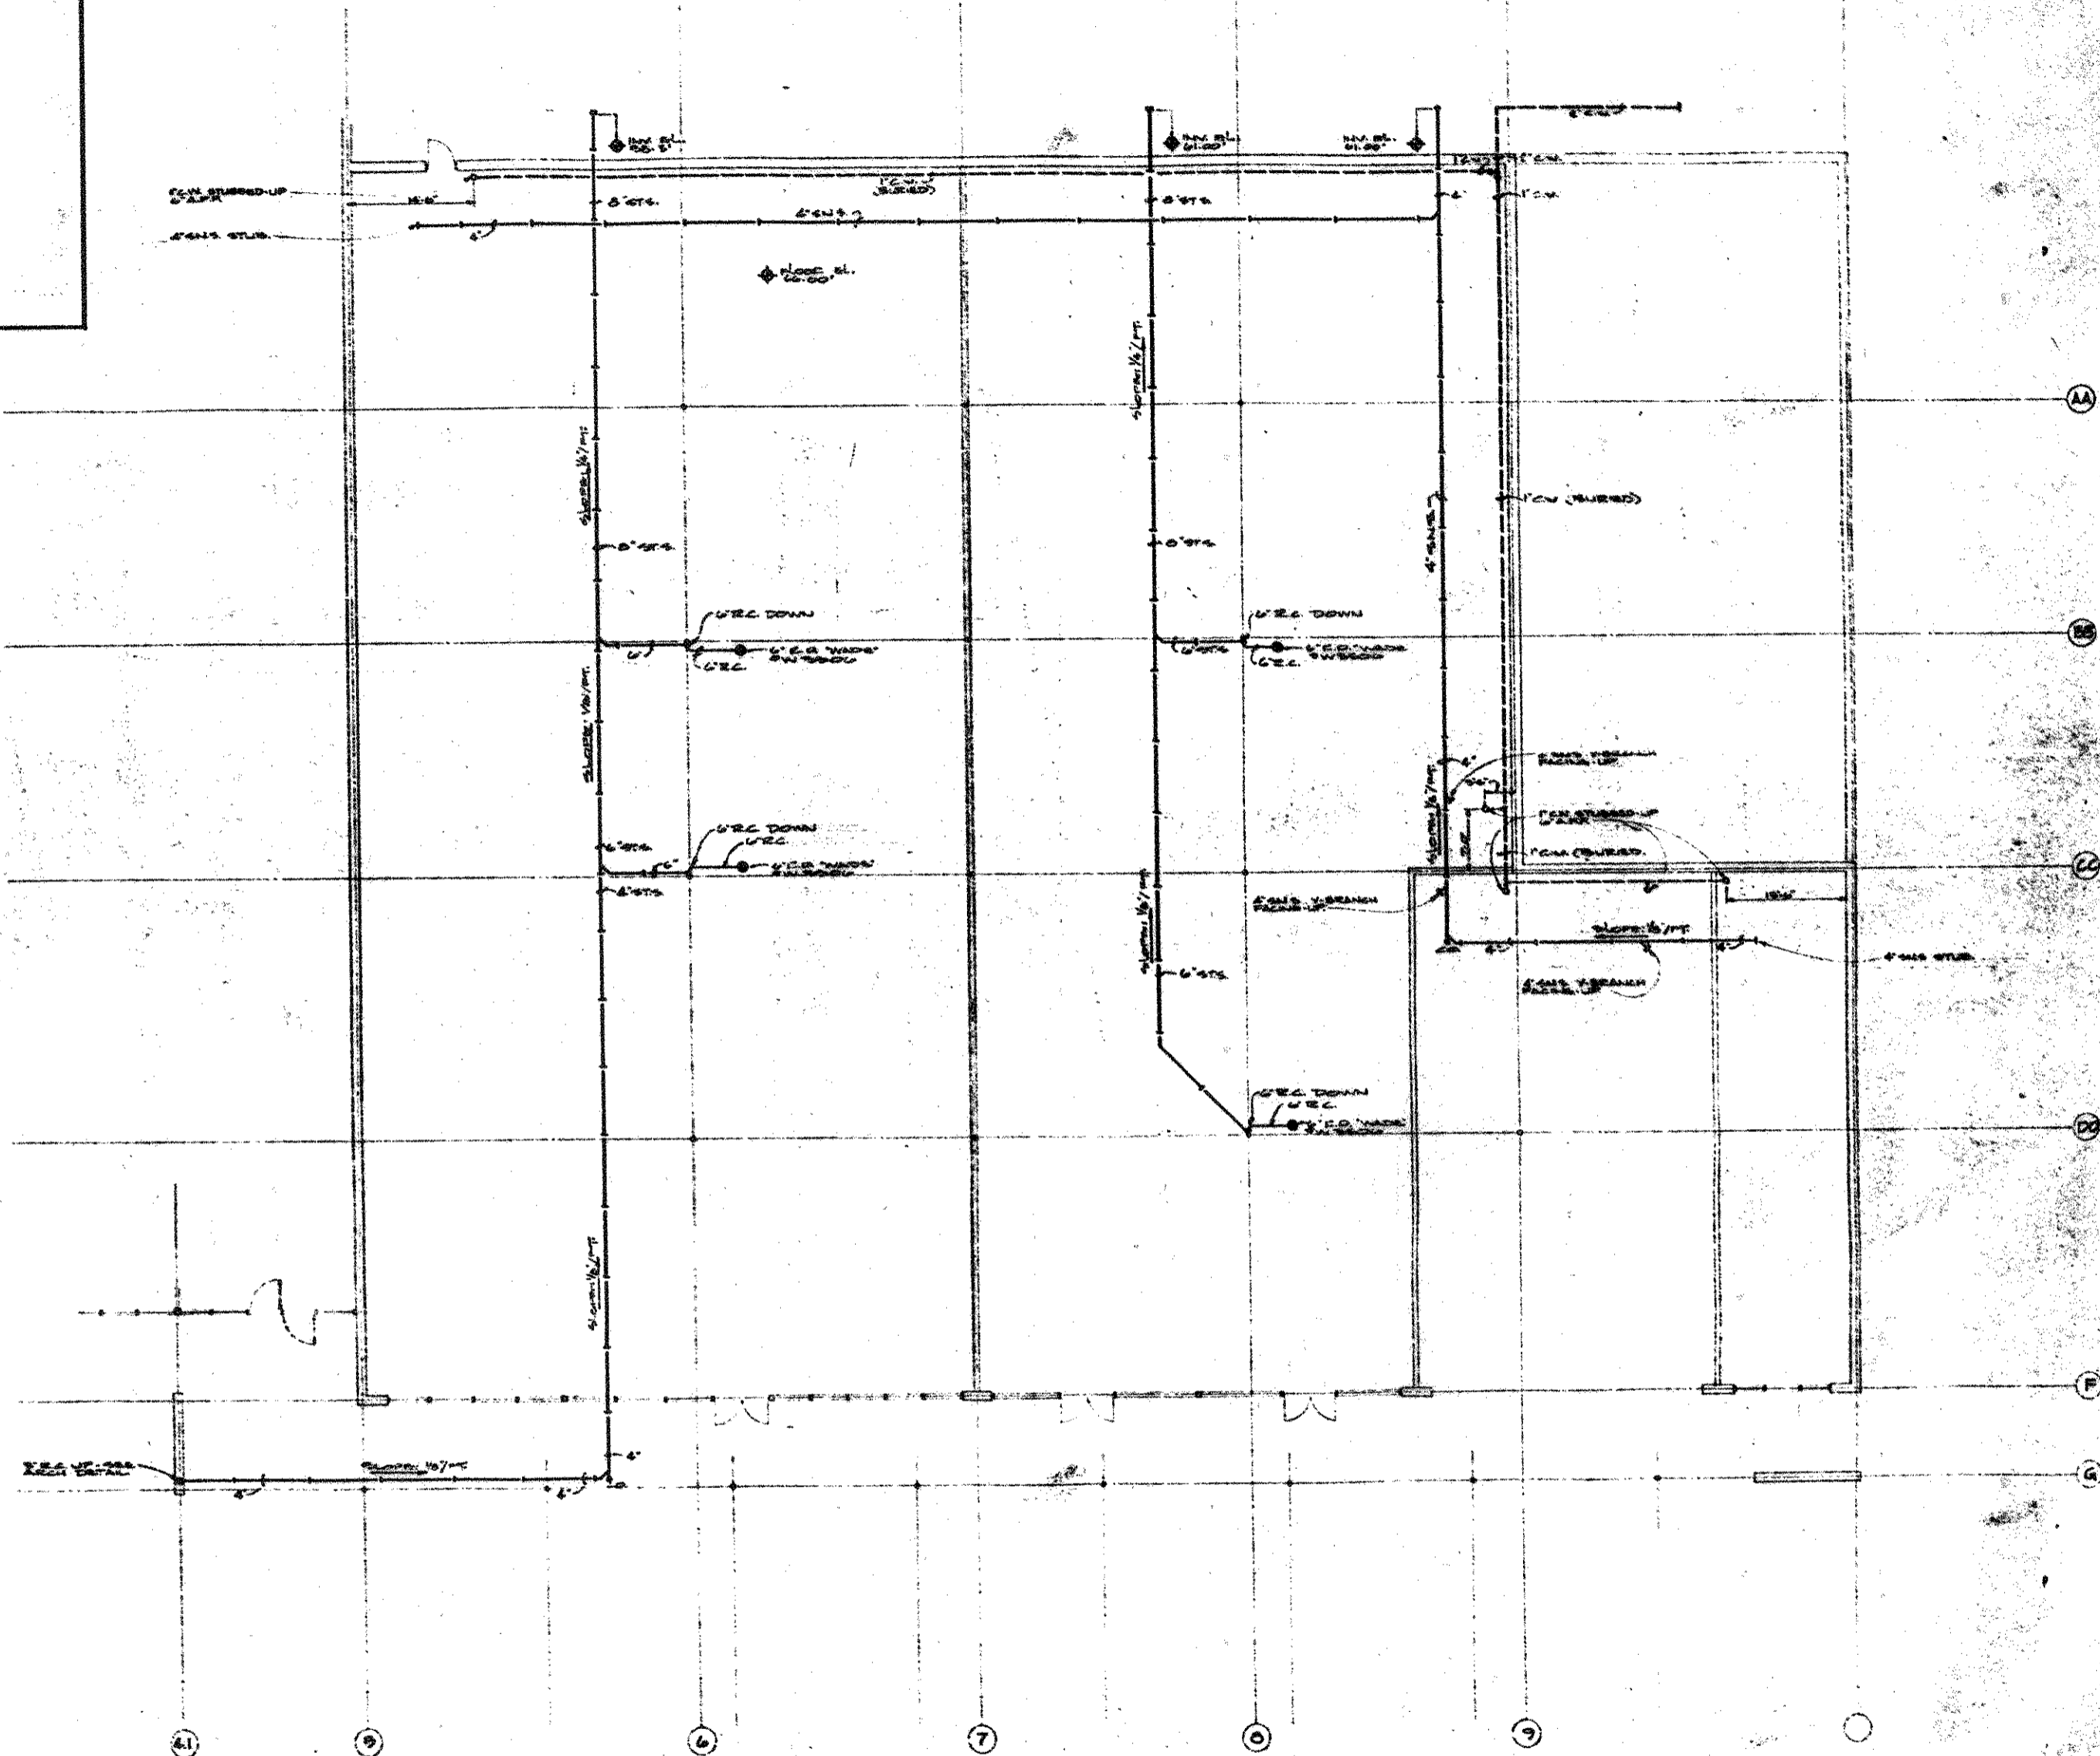

**PLUMBING FLOOR PLAN**  
SCALE: 1/8" = 1'-0"

**STEENWYK & THRAL ARCHITECTS**  
 35 LAFAYETTE N.E. Grand Rapids, Michigan 49503  
**SERVICE CENTER - PLUMBING FLOOR PLAN**  
 CORRIDOR HALL - BATH, INR