
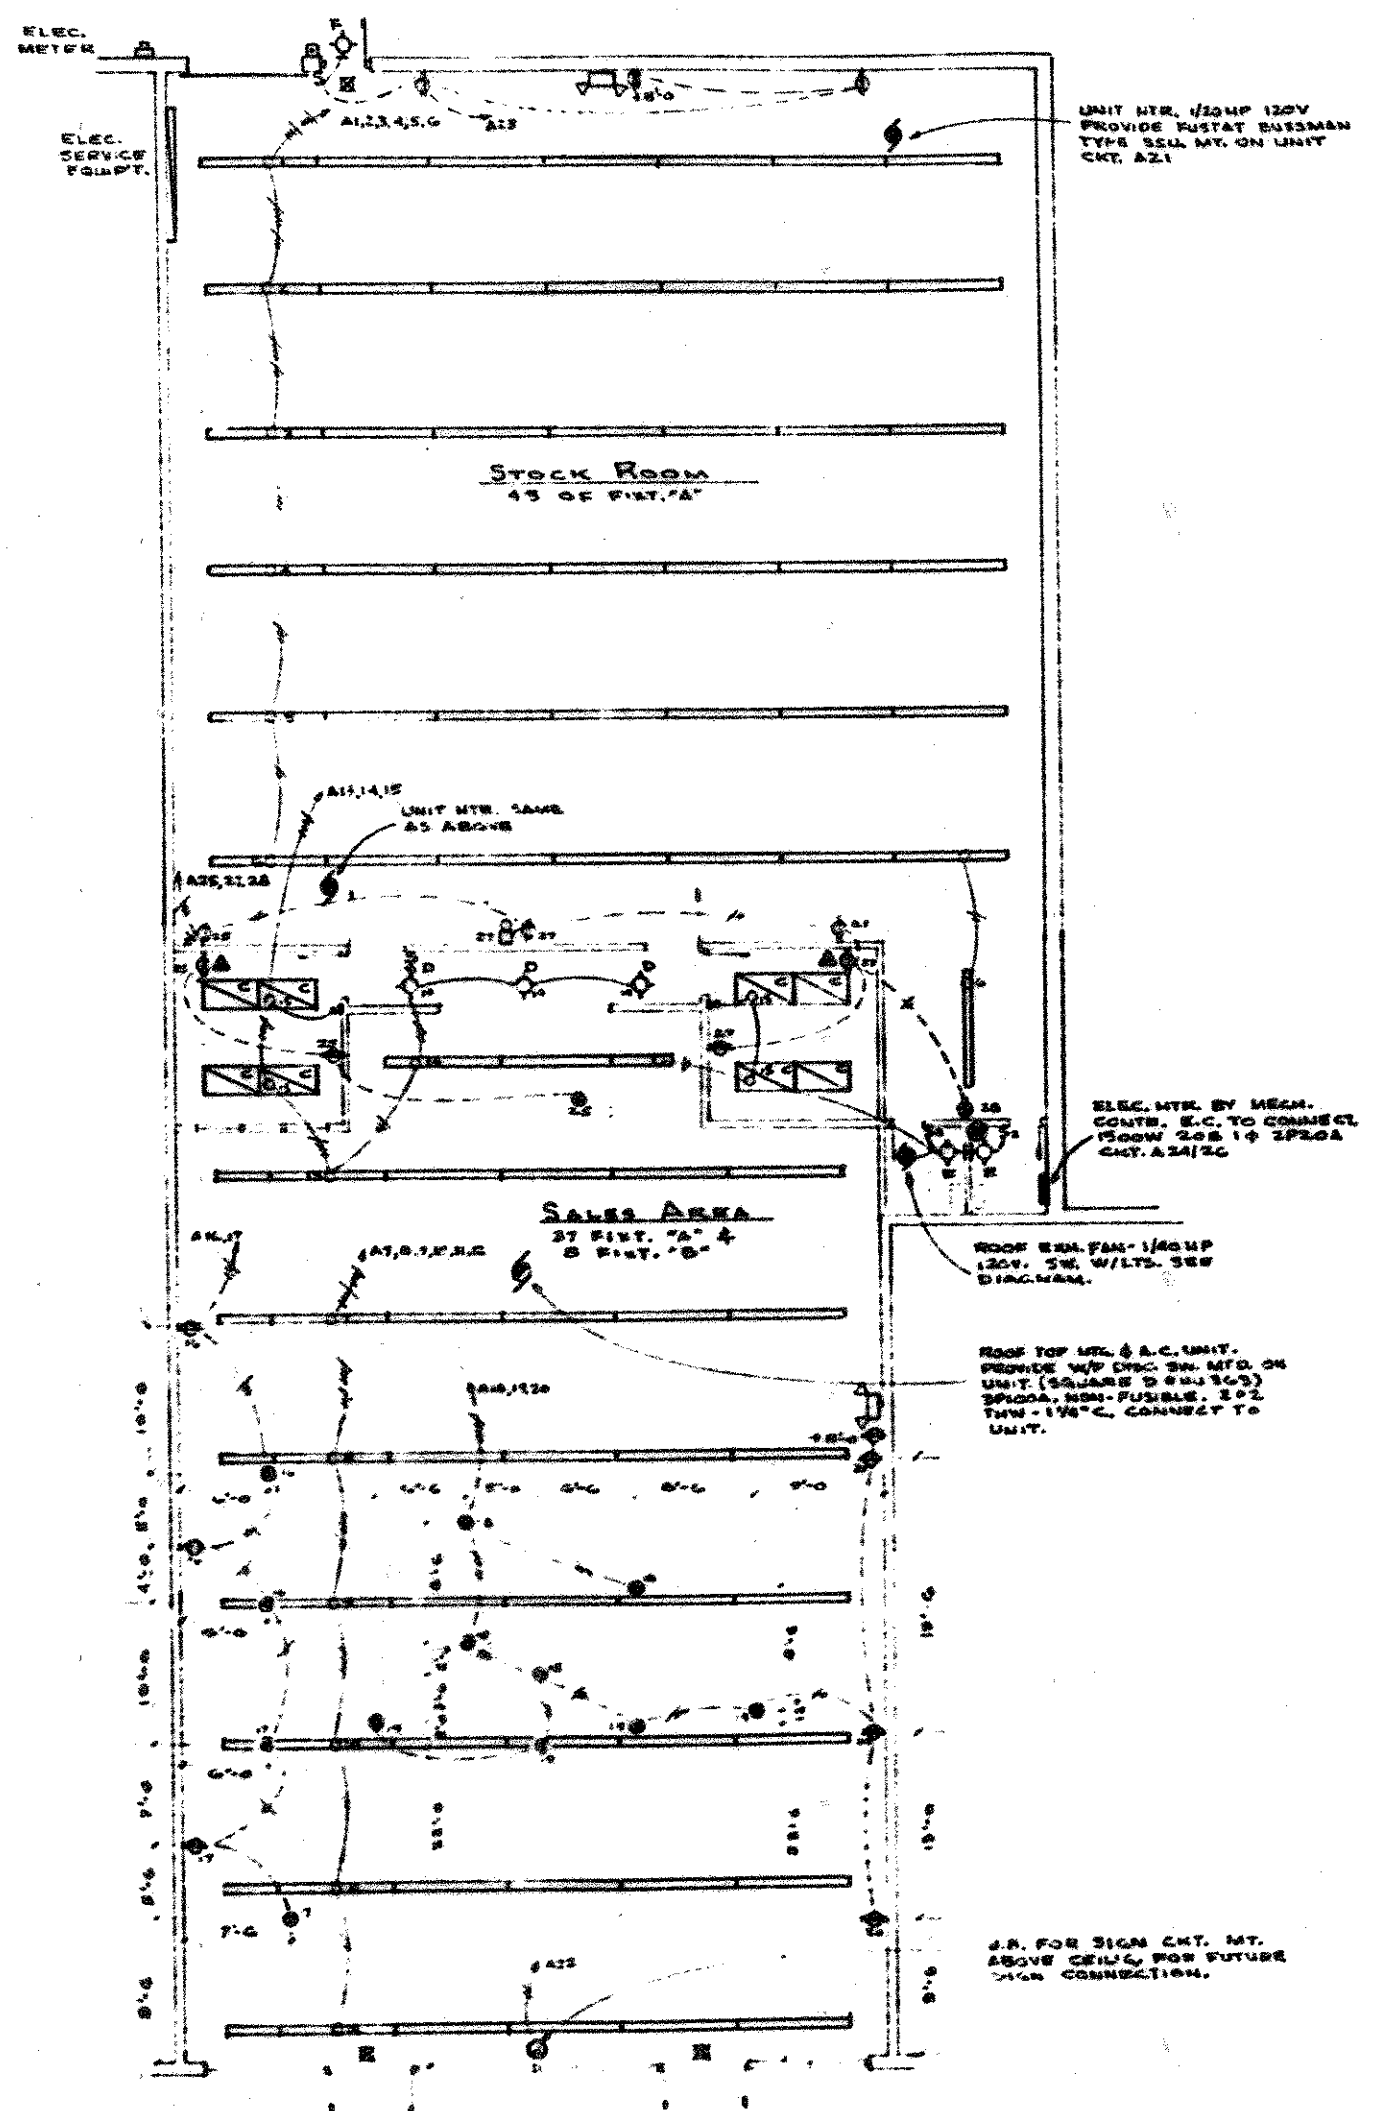
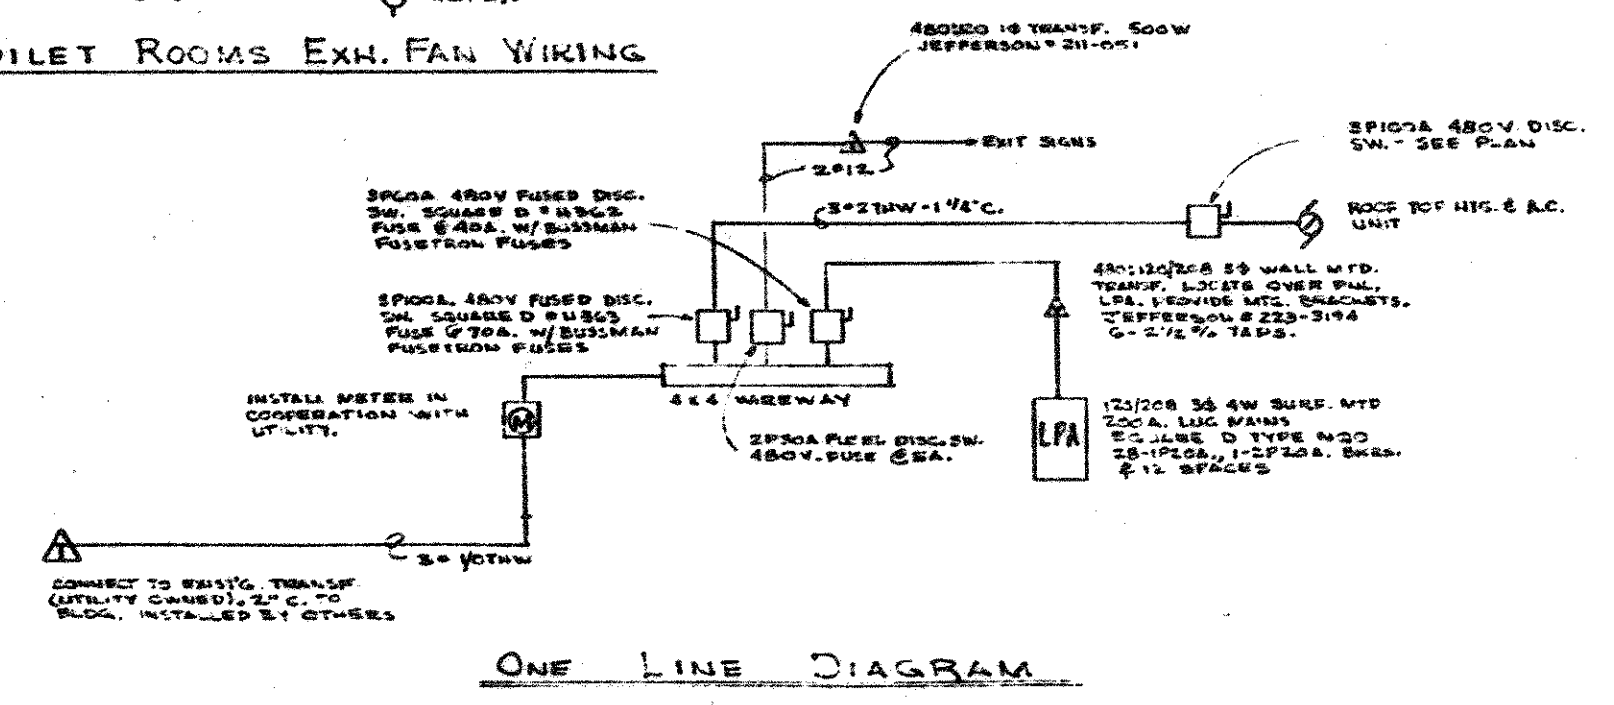


FIXTURE LEGEND				
SYM.	TYPE	MANF. & CAT. NO.	LAMPS	NOTES
A	6" FLOOR STRIP	HARVESTON # TR 9442	2- F56 CW	MT. TO BOTTOM OF JOISTS OR T-BARS (CHECK GAS LINE)
B	4" " "	" # TR 4442	2- F48 CW	
C	2x4 FLOOR LAY-IN	WAKEFIELD # SF-224C-55	2- F40 R/S CW	
D	RECESS INCAND.	ARTMETAL # 7402AA	1-150W PAR 38	
E	WALL MT.	" # 9000	2- 50W	MT. @ 7'6"
F	" " "	" # 3572A	1- 150W	MT. 1/2" OVER DOOR

SYMBOL LEGEND		
SYM.	DESCRIPTION	NOTES
S	SINGLE POLE SWITCH - HUBBELL # 1201	MTG. HT. - 48"
S2	DOUBLE " " " " # 1202	" " " "
W	DUPLEX WALL OUTLET - " # 5242	AS NOTED - 18" ON
W2	DUPLEX FLOOR OUTLET - " # B-2529	(WITH 3/32" OUTLET & 3/8" 3/32" COVER)
ED	FUSIONITION - EDWARDS # 786-C	MTG. HT. - 48"
ED2	24VAC 4" BELL-EDWARDS # 352-4 WITH #592 TRANSFORMER	MTG. HT. - 10"0"
ES	EXIT SIGN - ARTMETAL # B-5W-1	MT @ 10'6" TO 6'
EB	EMER. BATTERY UNIT - DUAL-LITE # EDUX-55-2-25	MT @ 8'0"

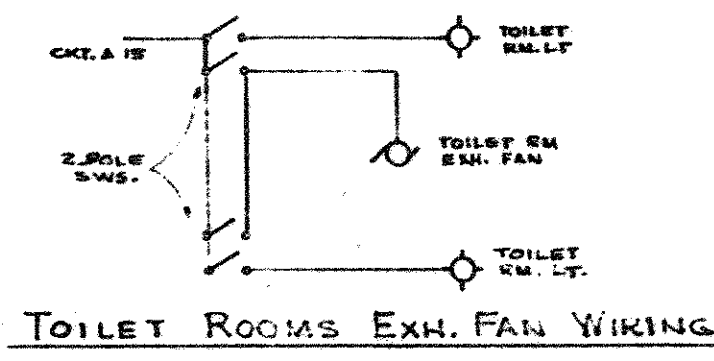

STEENWYK - THRALL ARCHITECTS
36 Lafayette N.E., Grand Rapids, Michigan 49503

FILE NO. 1405-1
SHEET NO. 1

TOPAZ CATALOG STORE
CONCORD MALL
ELKHART, IND.

ELECTRICAL PLAN