




SECTION
SCALE: 1/4" = 1'-0"

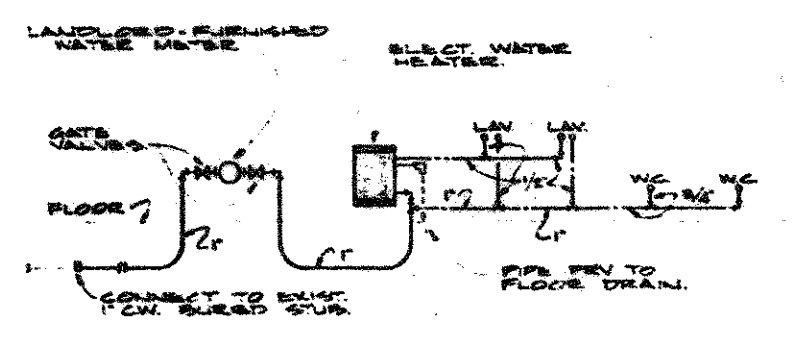

WATER PIPING SCHEMATIC
NO SCALE

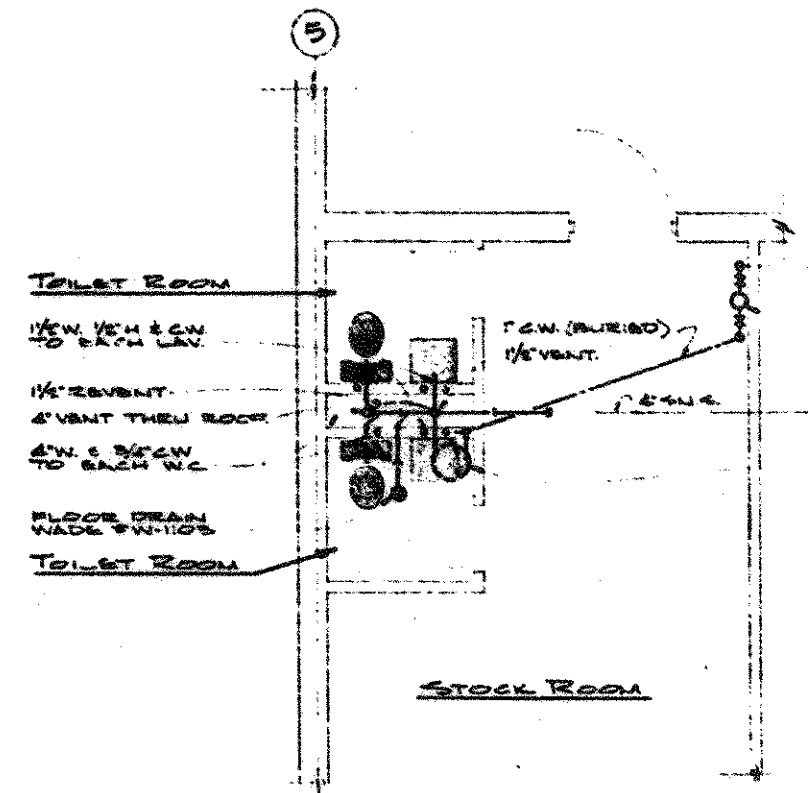

ENLARGED PLUMBING PLAN OF
TOILET ROOMS
SCALE: 1/4" = 1'-0"

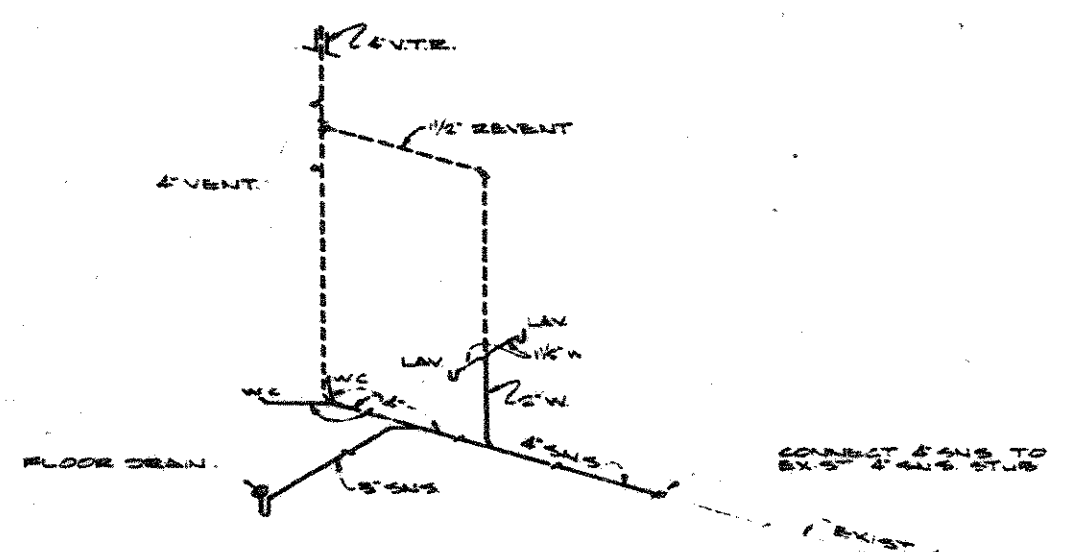


WASTE & VENT PIPING SCHEMATIC
NO SCALE

FIXTURE LEGEND	
1	WATER CLOSETS - (2 REQUIRED) ELONGATED CABINET #2010, 28" W/TANK COVER LOCKING DEVICE WITH #5520405 BLACK CERAMIC FRONT SEAT & SS CHECK HINGE & C.P. SUPPLIES W/KEY OPERATED STOP.
2	LAVATORIES - (2 REQUIRED) WALL HUNG LUBBER #0940, 28" x 18" W/ #2105 200 CERAMIC C.P. SUPPLIES W/KEY OPERATED STOP.

NOTE: PLUMBING FIXTURES BASED ON AMERICAN STANDARD

MECHANICAL LEGEND	
C.W.	COLD WATER
H.W.	HOT WATER
W.W.	WASTE
S.S.	SANITARY SEWER
V.	VENT
V.T.R.	VENT THROUGH ROOF
R.D.	ROOF DRAIN
W.H.	WATER HEATER
L.C.	LAVATORY
W.C.	WATER CLOSET
C.O.	CLEAN-OUT
S.A.D.	SUPPLY AIR DIFFUSER
E.A.D.	EXHAUST AIR DIFFUSER
R.A.D.	RETURN AIR DIFFUSER
S.A.	SUPPLY AIR
R.A.	RETURN AIR
F.D.	FIRE DAMPER
T.O.U.	ROOF TOP UNIT

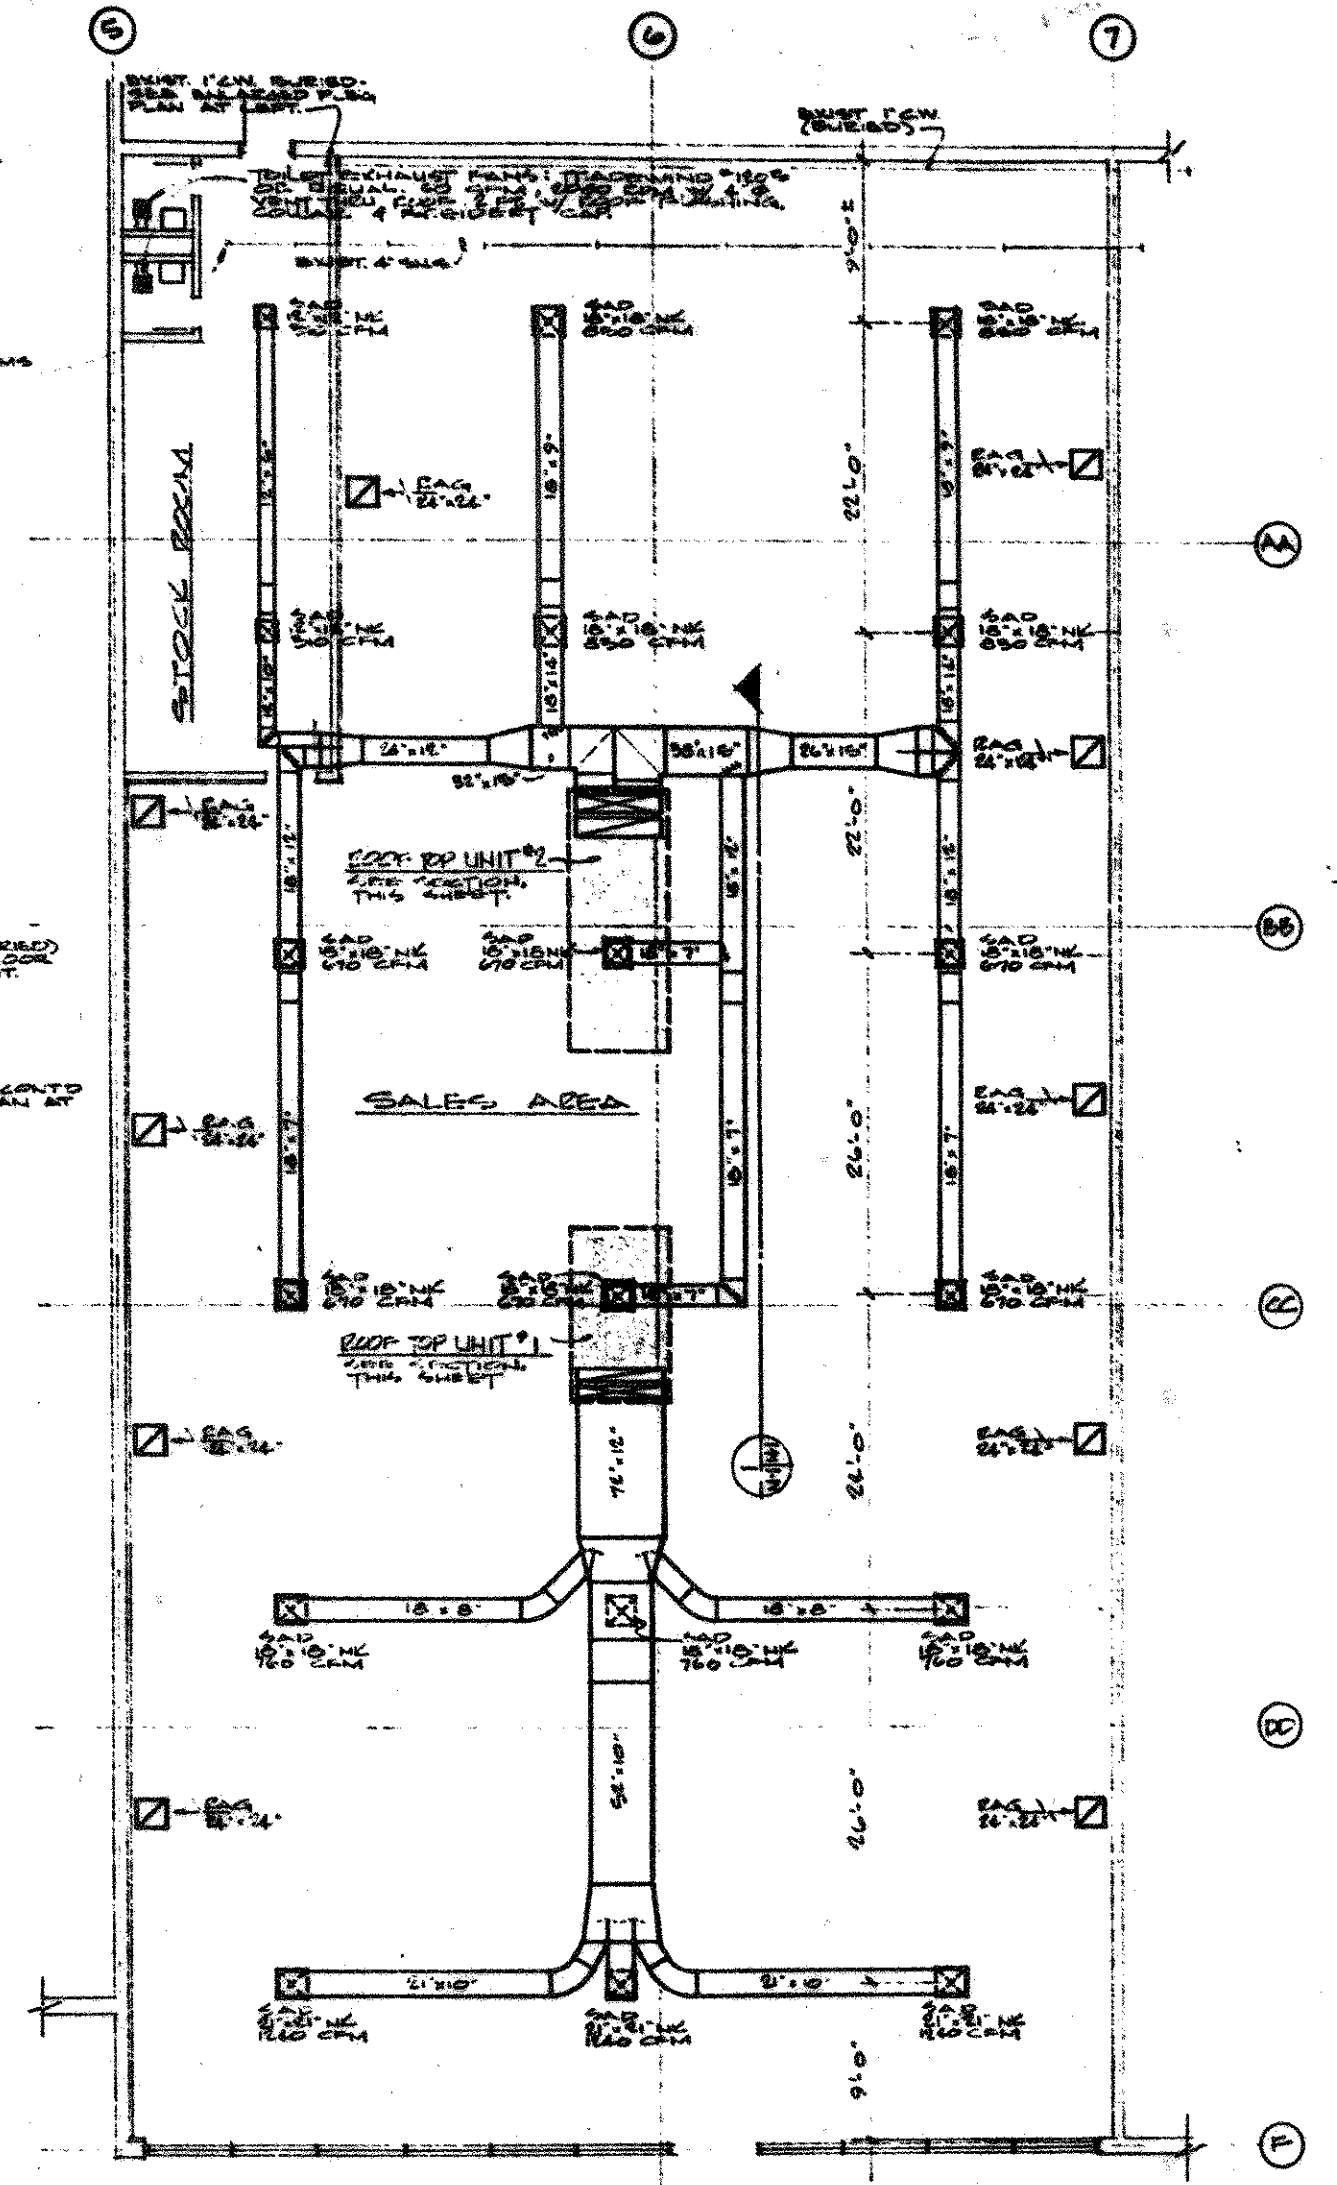

H.V.A.C. & PLUMBING FLOOR PLAN
SCALE: 1/4" = 1'-0"

STEENWYK - THRALL ARCHITECTS
35 Lafayette N.E., Grand Rapids, Michigan 49503

JO ANN FABRIC SHOP
CONCORD MALL
INDIANA

THE ARCHITECTS ENGINEERING CONSULTANTS
ASSOCIATION OF GRAND RAPIDS, MICHIGAN, INC.
SUPERIOR ST., GRAND RAPIDS, MICH. 49503 - 241-0000

