


1 REFLECTED CEILING PLAN  
A8-1 SCALE: 1/4" = 1'-0"

**REFLECTED CEILING PLAN NOTES:**

- COORDINATE WITH MECHANICAL, ELECTRICAL AND PLUMBING DRAWINGS FOR ALL LIGHTS, DUCTS, SPRINKLER DROPS, AND OPENINGS IN CEILINGS.
- GYPSUM BOARD EXPANSION JOINTS SHALL BE REQUIRED, TYPICAL AT EACH CORNER AND ANGLE BREAK OF INTERIOR FURR DOWNS.
- LIGHTING TO BE CONTROLLED VIA LIGHTING CONTACTORS IN STOCK ROOM AND SWITCH BANK(S) IN CORRIDOR.
- REFER TO FINISH SCHEDULE ON A10-1 FOR ALL FINISHES

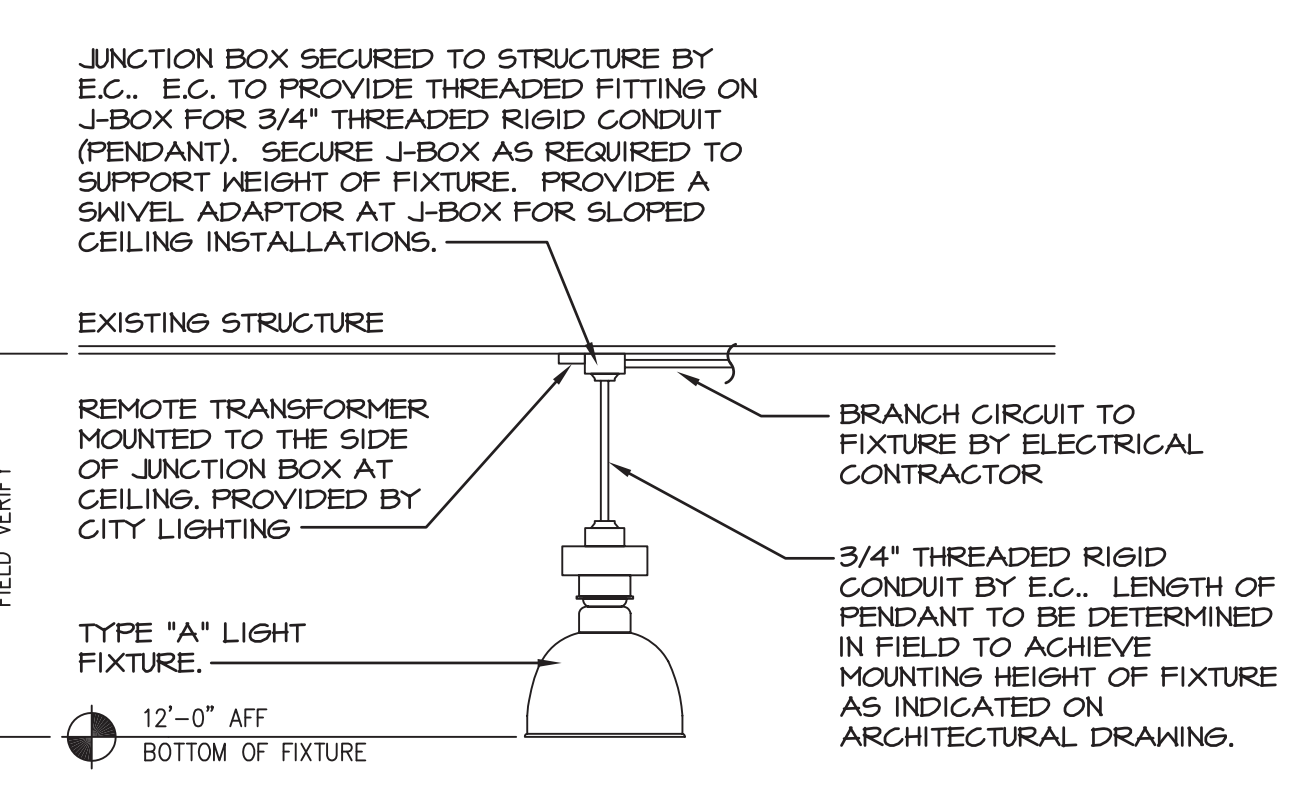

2 DETAIL AT HIGH BAY FIXTURES  
A8-1 NOT TO SCALE

LIGHT FIXTURE SCHEDULE					
TAG	LAMP	SYMBOL	TYPE	DESCRIPTION	NOTES
A	175W METAL HALIDE	⊙	SUSPENDED HI-BAYS	HUBBELL LIGHTING- SUPER BAY PA2 SERIES BLA175PB4H-BLPA2-BLPKENC	BOTTOM OF LENS AT 12'-0" AFF. PROVIDE NIGHT LIGHTS. SEE DETAIL 2/A8-1.
A1	MP100UMED	⊙	SUSPENDED HI-BAYS	JUNO LIGHTING-ACQUILITE, SIMCOE GLASS REFLECTOR SOL-EDIT-S10 WITHOUT LOUVER.	BOTTOM OF FIXTURE AT 12'-0" AFF. SEE DETAIL 2/A8-1.
B	(2) 32W T8	—	STRIP FLOURESCENTS	8' STRIP LIGHTING WITH ELECTRONIC BALLASTS.	SUSPENDED AT 12'-0" AFF.
C	15W LED PAR 30	⊙	TRACK LIGHTS	HALO POWER TRAC LIGHTING SYSTEMS #LT130PX TRACKS 4 HEADS, WHITE.	SUSPENDED FROM ABOVE AT 12'-0". 24 LINEAR FOOT OF TRACK PER EACH 20 AMP CIRCUIT MAXIMUM.
D	23W CFL	⊙	WALL MOUNTED STREET LIGHTS	WALL SCONES, INSTALL IN LOCATIONS SHOWN.	PAINT ALL EXPOSED SCREW HEADS BLACK. INSTALL AFTER INSTALLATION OF WALLCOVERINGS/FIXTURES
E	23W CFL	⊙	LAMP POST	FLOOR MOUNTED LAMP POST FIXTURE	PAINT ALL EXPOSED SCREW HEADS BLACK
F	100W TYPE-A	⊙	LIGHT/FAN COMBO	COMBINATION LIGHT AND EXHAUST FAN, COLOR: WHITE	
X	LED	⊙	EXIT SIGN	EXIT SIGN WITH BATTERY BACKUP	INSTALL BREAKER LOCKS ON CIRCUITS FOR EMERGENCY LIGHTING. CENTER ABOVE DOORS.
Y	(2) ADJUSTABLE HEADS	⊙	EMERGENCY LIGHTS	EMERGENCY LIGHTING WITH BATTERY BACKUP.	SUSPENDED AT 12'-0" AFF. INSTALL BREAKER LOCKS ON CIRCUITS FOR EMERGENCY LIGHTING
Y1	(2) ADJUSTABLE HEADS	⊙	EMERGENCY LIGHTS	WALL MOUNTED EMERGENCY LIGHTING WITH BATTERY BACKUP	INSTALL BREAKER LOCKS ON CIRCUITS FOR EMERGENCY LIGHTING

KEY NOTES						
TAG	DESCRIPTION	EXISTING	N/A	CURRENT SCOPE	TENANT'S VENDOR	NOTES
1	SUSPENDED CEILING ELEMENT, 40LBS TOTAL, HUNG WITH 6 MOUNTING CLIPS/WIRE CAPABLE OF 40LBS EACH.			●	●	MOUNT FROM STRUCTURE ABOVE WITH CABLES. BOTTOM AT 12'-0" AFF. REFER TO SHEET A7-1
4	INSTALL TRACKS APPROXIMATELY 4 INCHES FROM STOREFRONT			●	●	
5	TENANT'S BANNER HANGING SYSTEM, MUST BE MOUNTED HIGHER THAN STOREFRONT GLASS HT.			●	●	SEE DETAIL 6/A7-1, INSTALL ALL PROVIDED CLIPS
6	DRYWALL CEILING IN RESTROOM			●	●	PAINT PT1
7	OPEN TO STRUCTURE ABOVE			●	●	
8	TENANT SIGNAGE			●	●	GC TO PROVIDE BLOCKING AS NEEDED FOR INSTALLATION OF SIGNAGE
9	PROVIDE DEDICATED CIRCUIT ROUTED THROUGH TIME CLOCK			●	●	TENANT GC TO PROVIDE ADDITIONAL CIRCUIT/POWER FOR INTERIOR SIGN
10	SECURITY CAMERA DOME. (G.C. TO NOTIFY RUE IF CAMERA DOME WILL BE NON VISIBLE ONCE INSTALLED)			●	●	SUSPEND FROM ABOVE WITH CONDUIT PAINTED PT1, MOUNT TO JUNCTION BOX AT 12'-0" AFF.
11	SUSPENDED CEILING ELEMENT, REFER TO SHEET A7-1.			●	●	MOUNT FROM STRUCTURE ABOVE WITH CABLES AT 12'-0" AFF. (NO)
12	CREATE PLATFORM ABOVE RESTROOMS FOR WATER HEATER. REFER TO DETAILS ON SHEET A7-1.			●	●	MARK RESTROOM WALLS 'NO STORAGE ABOVE'
15	ELECTRICAL RECEPTACLES MOUNTED ON CEILING FOR TV/SECURITY CAMERA LOCATIONS			●	●	MOUNT OUTLET AT HEIGHT OF BAR JOISTS
16	1 BANNER HANGER-RUN AIRCRAFT CABLE DOWN FROM UNISTRUT TO 12'-0" AFF W/ HANGING LOOPS			●	●	PROVIDE (1) 4" SECTION OF UNISTRUT ON EACH SIDE SUSPENDED FROM STRUCTURE ABOVE. REFER TO SHEET A7-1
17	WALL MOUNTED PRE-FINISHED TRIM AT 11'-0" AFF. PAINTED PT3 (TAN)			●	●	CONTINUOUS IN SALES AREA AND FITTING ROOM. ALSO REFER TO INTERIOR ELEVATIONS, SHEET A6-1
18	LIGHT GAUGE METAL STUD BRACING BETWEEN FLOATING WALLS AND STOREFRONT			●	●	8'-0" MAX SPACING. WRAP WITH DRYWALL, PAINT PT1
19	DRYWALL BULKHEAD AT 1'-0" AFF			●	●	PAINT PT1
20	REMOTE EXTERIOR EGRESS ILLUMINATION, CONNECTED TO INTERIOR EXIT SIGN			●	●	

**Hermes Architects**

Members A.I.A.  
1777 West Loop South, Ste. 500  
Houston, Texas 77027  
Tel: 713-765-3644  
www.hermesarchitects.com  
Houston • Dallas • Ft. Worth

This document is an instrument of service protected by the copyright law of the United States of America, 17 U.S.C. § 102, and shall not be copied or reproduced without the express written consent of Hermes Architects, Inc.

**INCOMPLETE DRAWING - DO NOT USE FOR REGULATORY APPROVAL, PERMIT OR CONSTRUCTION**  
ARCHITECT: Roger R. Wrede  
REGISTRATION #: 17468  
DATE: 09/23/2011

CROSSROADS MALL  
RUE 21  
GREENVILLE  
6834 WESLEY STREET  
GREENVILLE, TEXAS 75401

**Crossroads**  
GREENVILLE PROPERTIES LTD.  
10850 WILCHIRE BLVD.  
SUITE 1050  
LOS ANGELES, CA 90024

DATE: SEPTEMBER 2, 2011  
PROJECT NO.: 809501  
DRAWN BY: --  
CHECKED BY: --

REFLECTED CEILING PLAN AND DETAILS

RUE-A8-1

K:\809500\DRAWINGS\4-PLT SHEETS\SHEETS\RUE-A8-1 REFLECTED CEILING PLAN AND DETAILS.DWG  
9/6/2011 7:52:52 AM  
AMY PECTON