


1 PLUMBING ROOF PLAN
SCALE 1/8" = 1'-0"

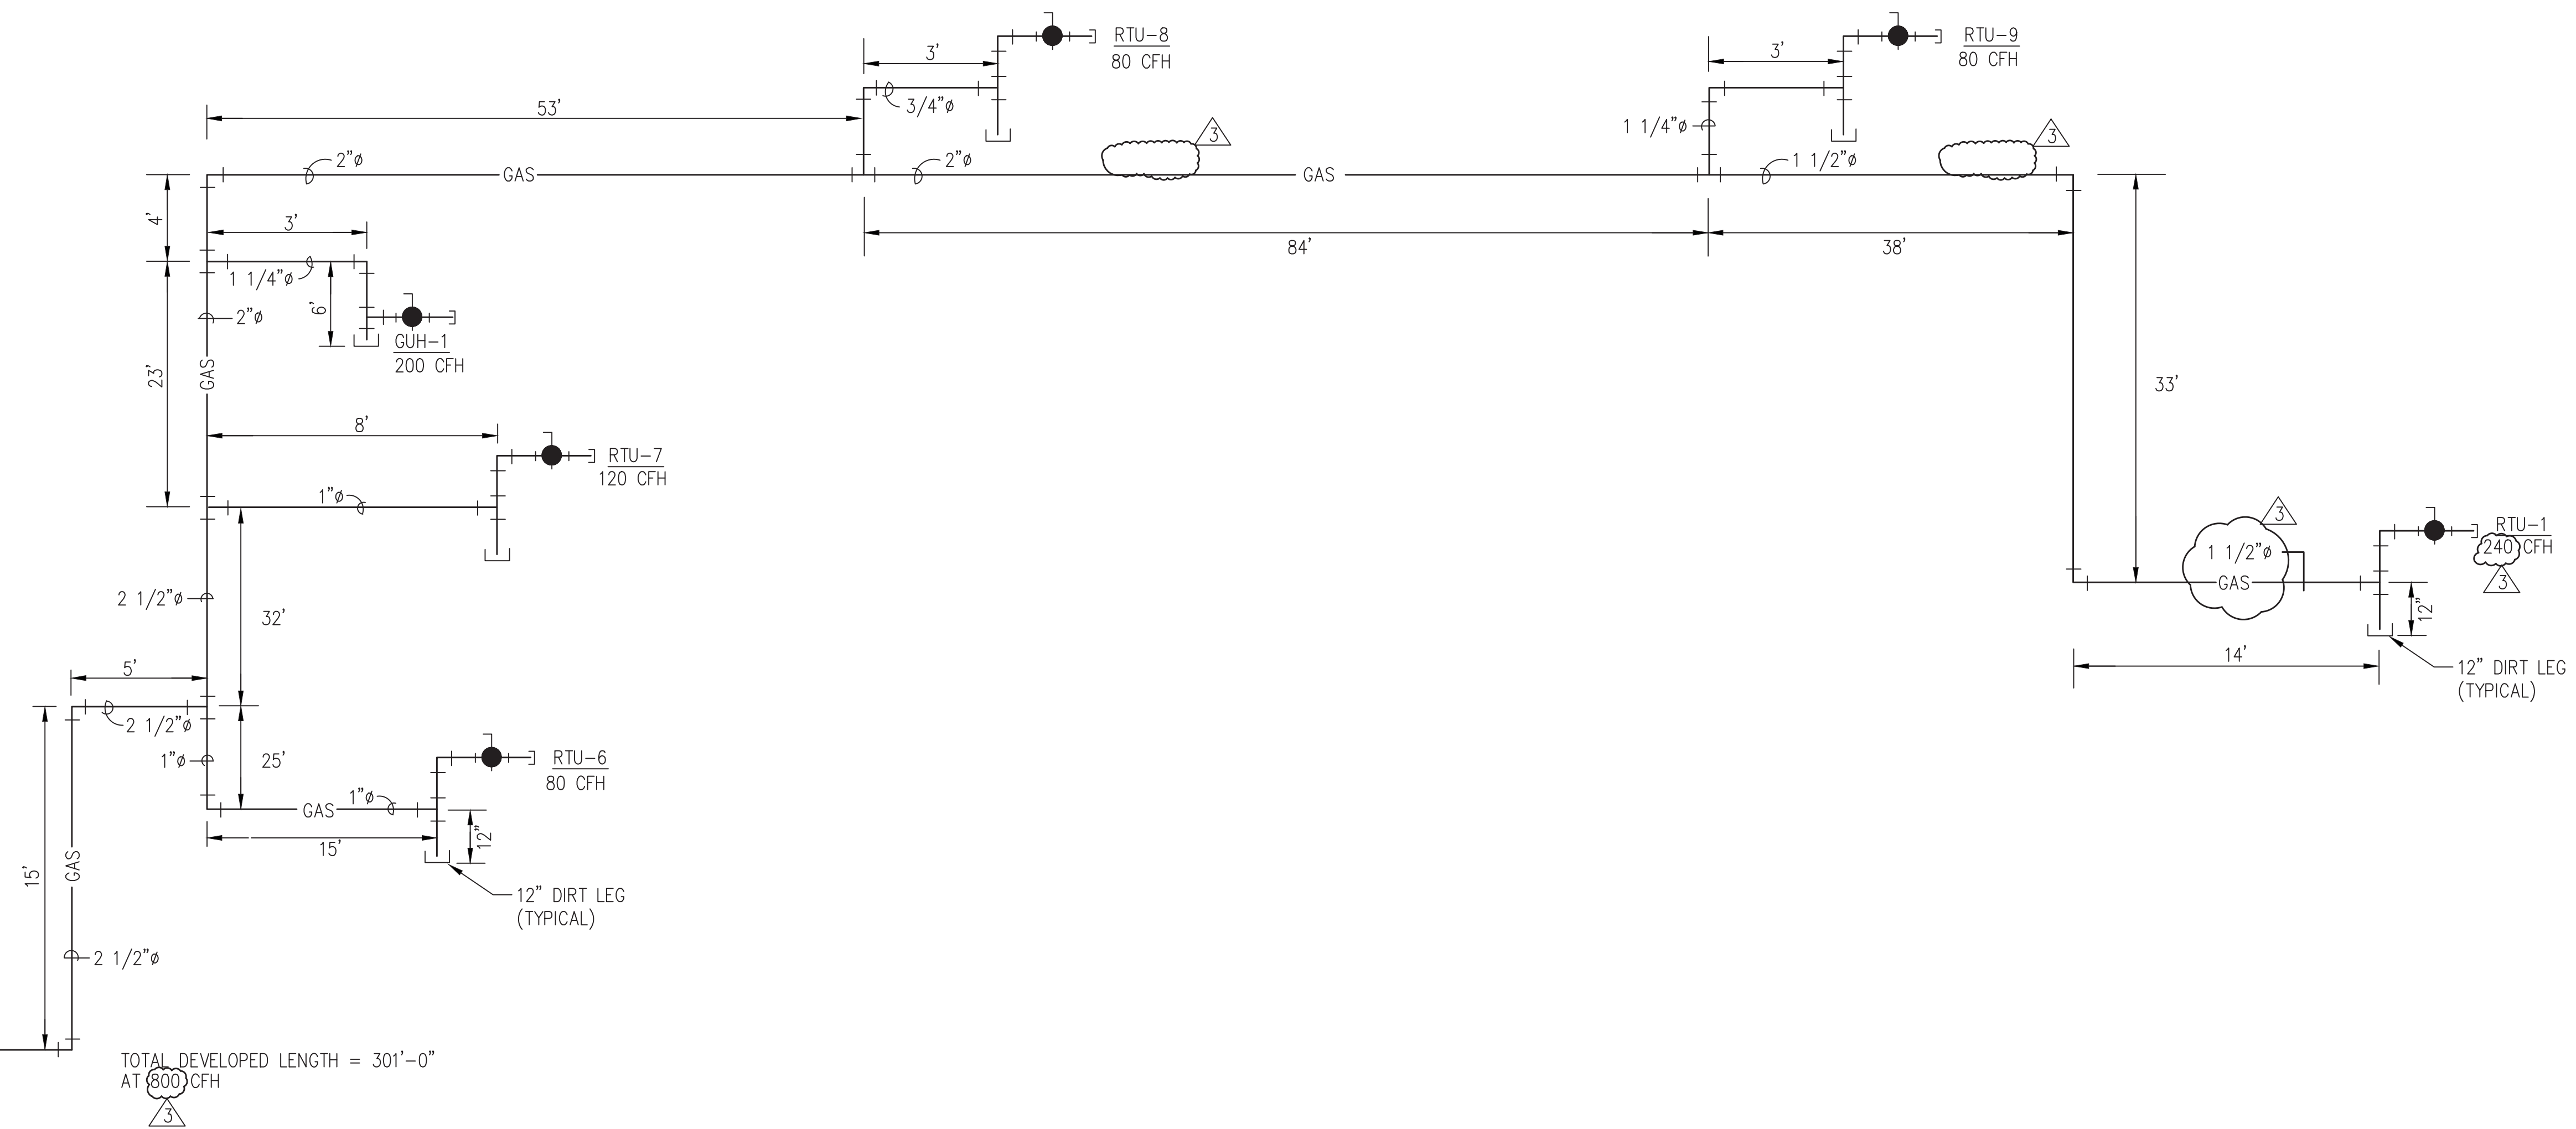

2 GAS PIPING RISER DIAGRAM
SCALE: NTS