

## SITE PLAN.- PHOTOMETRICS


Plan View  
Scale: 1"=10'

LUMINAIRE SCHEDULE									
Symbol	Label	Qty	Catalog Number	Description	Lamp	File	Lumens	LLF	Watts
	S1	2	LITHONIA® KV33 1000M R5 ON RT5501 POLE	VERTICAL LAMP, CUT-OFF LUMINAIRE	ONE 1000-WATT CLEAR BT-56 METAL HALIDE, VERTICAL BASE-UP POSITION.	KV33_1000M_R5.dwg	110000	0.72	1680
	S2	1	LITHONIA® (2)KV53 1000M R5 ON RT5501 POLE	VERTICAL LAMP, CUT-OFF LUMINAIRE	ONE 1000-WATT CLEAR BT-56 METAL HALIDE, VERTICAL BASE-UP POSITION.	KV53_1000M_R5.dwg	110000	0.72	2160
	B	3	LITHONIA® W5Q 150MHC FT MOUNTED AT 12FT AFG.	ARCHITECTURAL SCIENCE WITH FORWARD THROW DISTRIBUTION WITH CLEAR, FLAT GLASS LENS, CLEAR LAMP. MEETS THE NIGHTTIME FRIENDLY CRITERIA	ONE 150-WATT CLEAR ED17 CERAMIC METAL HALIDE, HORIZONTAL POS.	W5Q_150MHC_FT.dwg	14000	0.72	208

STATISTICS						
Description	Symbol	Avg	Max	Min	Max/Min	Avg/Min
SITE	+	2.8 fc	9.0 fc	0.5 fc	18.0:1	5.6:1

LUMINAIRE LOCATIONS							
No.	Label	X	Location Y	Z	MH	Orientation	Tilt
1	S1	-2263.7	4852.8	52.0	52.0	90.0	0.0
2	S1	-2076.7	4851.5	52.0	52.0	-90.0	0.0
3	S2	-2169.0	4769.4	52.0	52.0	90.0	0.0
4	B	-2295.5	4888.2	12.0	12.0	0.0	0.0
5	B	-2174.1	4888.7	12.0	12.0	0.0	0.0
6	B	-2143.1	4889.2	12.0	12.0	0.0	0.0

**WINDLE + VOLPE**  
 ARCHITECTS  
 7600 WESTFIELD  
 HOUSTON, TEXAS 77063  
 PH 713-951-1390

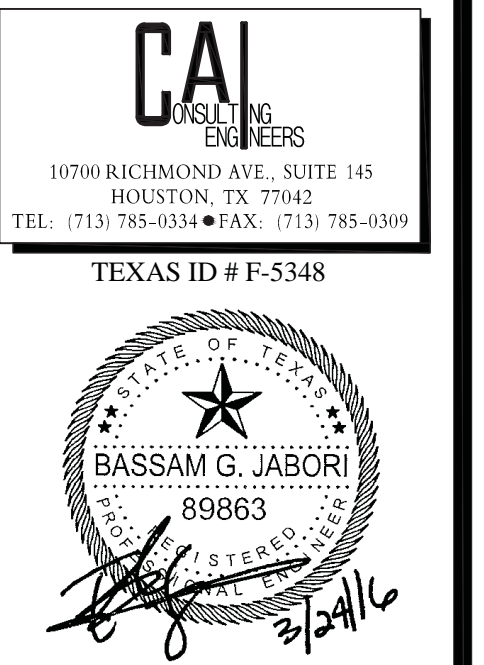

**PAD BUILDING AT THE CROSSROADS MALL**  
 GREENVILLE, TEXAS  
**GREENVILLE PROPERTIES LTD.**  
 GREENVILLE, TEXAS

DATE	4/1/16
PROJECT NO.	08-14-05
DRAWN BY	

ELECTRICAL  
SITE PLAN  
PHOTOMETRICS

E0.1