



| DETAIL DIM. 'A' | DIM. 'B' |
|-----------------|----------|
| B | 3'-4" |
| | |
| | |
| | |
| | |

NOTES:
ELECTRICAL CONTRACTOR TO PROVIDE AND INSTALL LIGHT FIXTURES. REFER TO ELECTRICAL PLANS FOR QUANTITIES AND SPECIFICATIONS.

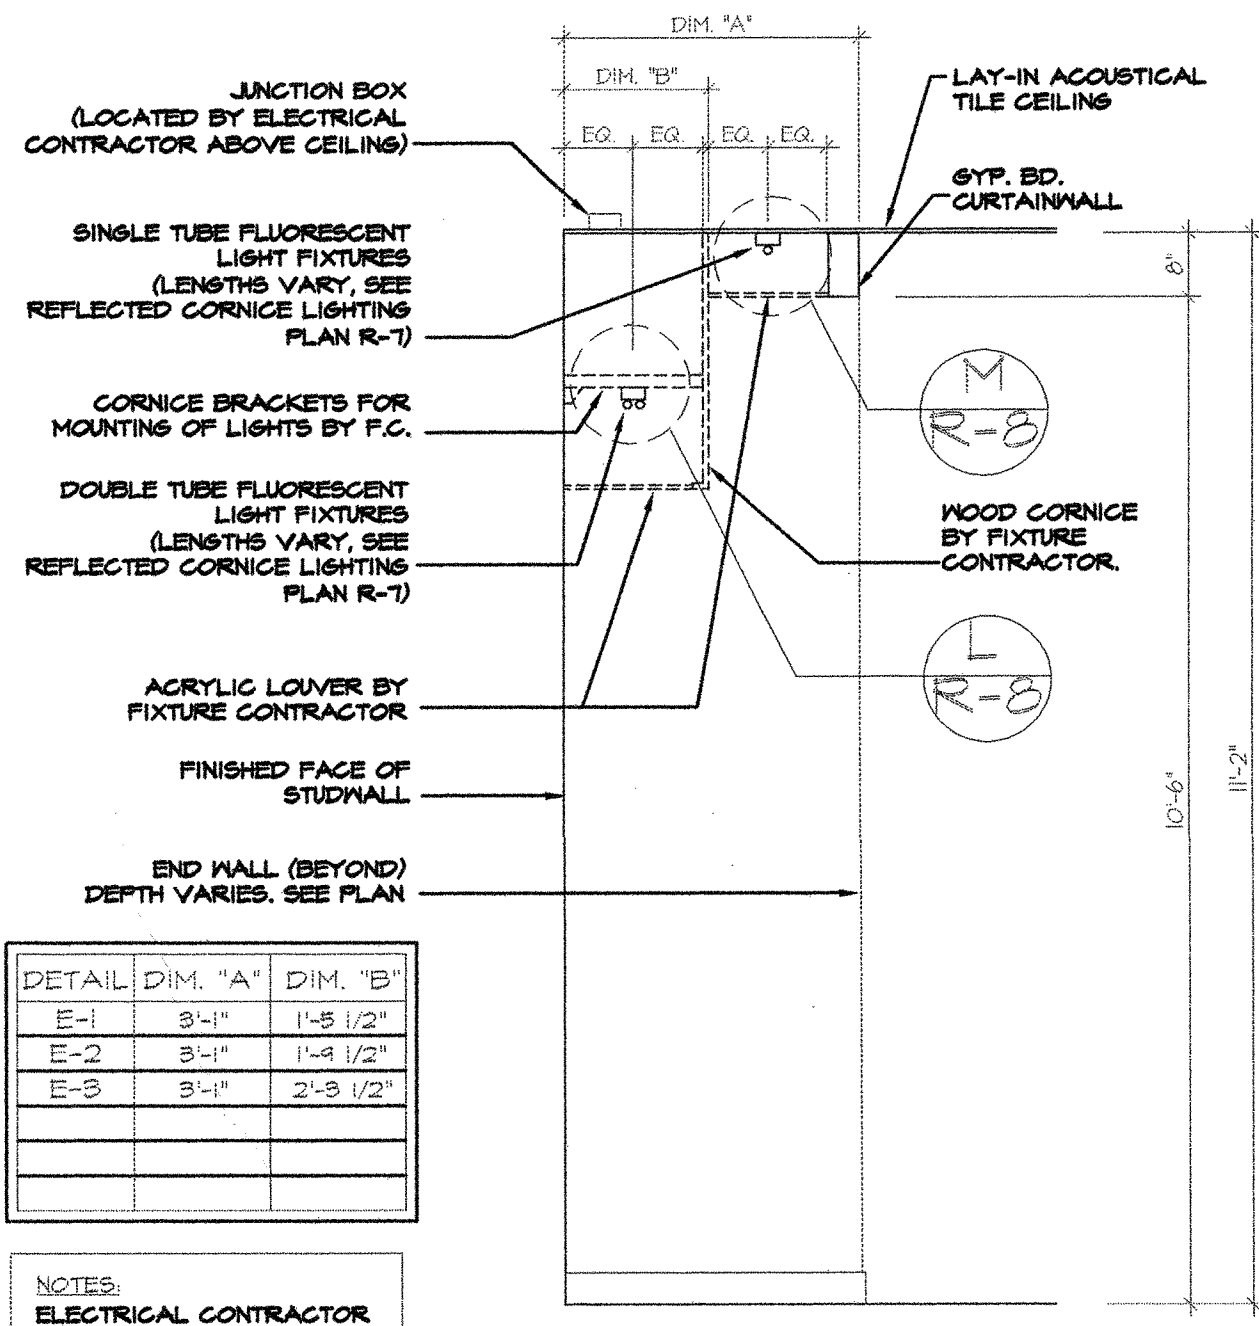


| DETAIL DIM. 'A' | DIM. 'B' |
|-----------------|-----------------|
| E-1 | 3'-4" 1'-8 1/2" |
| E-2 | 3'-4" 1'-4 1/2" |
| E-3 | 3'-4" 2'-8 1/2" |
| | |
| | |

NOTES:
ELECTRICAL CONTRACTOR TO PROVIDE AND INSTALL LIGHT FIXTURES. REFER TO ELECTRICAL PLANS FOR QUANTITIES AND SPECIFICATIONS.

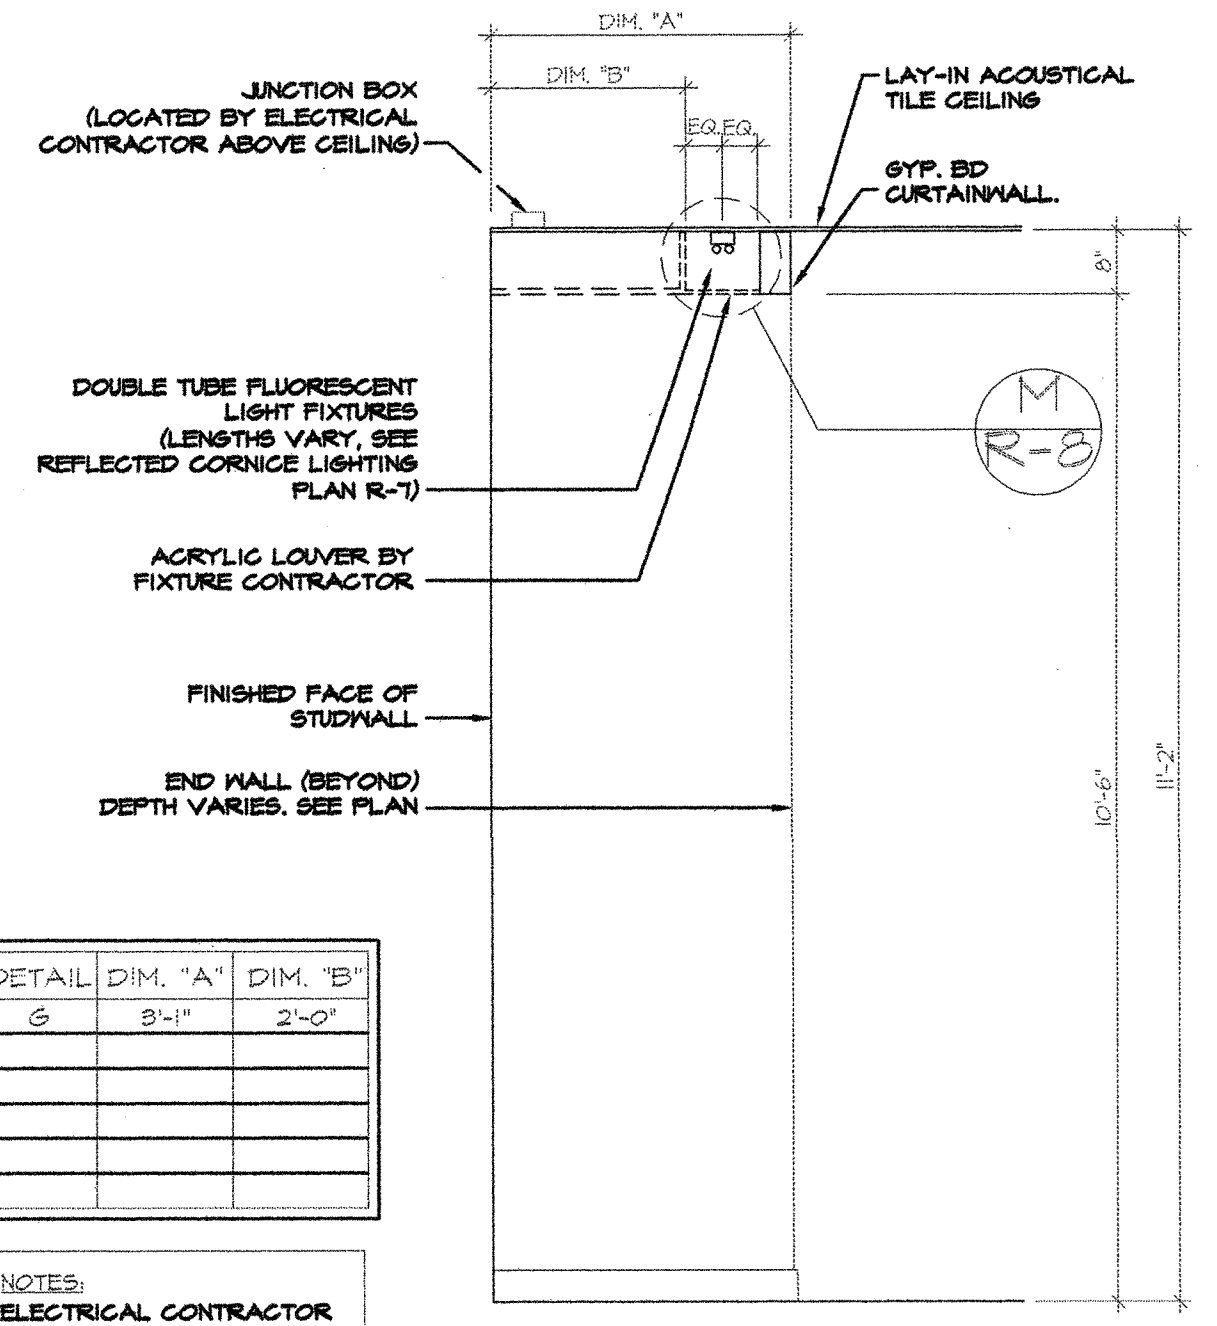


| DETAIL DIM. 'A' | DIM. 'B' |
|-----------------|-------------|
| G | 3'-4" 2'-0" |
| | |
| | |
| | |
| | |

NOTES:
ELECTRICAL CONTRACTOR TO PROVIDE AND INSTALL LIGHT FIXTURES. REFER TO ELECTRICAL PLANS FOR QUANTITIES AND SPECIFICATIONS.

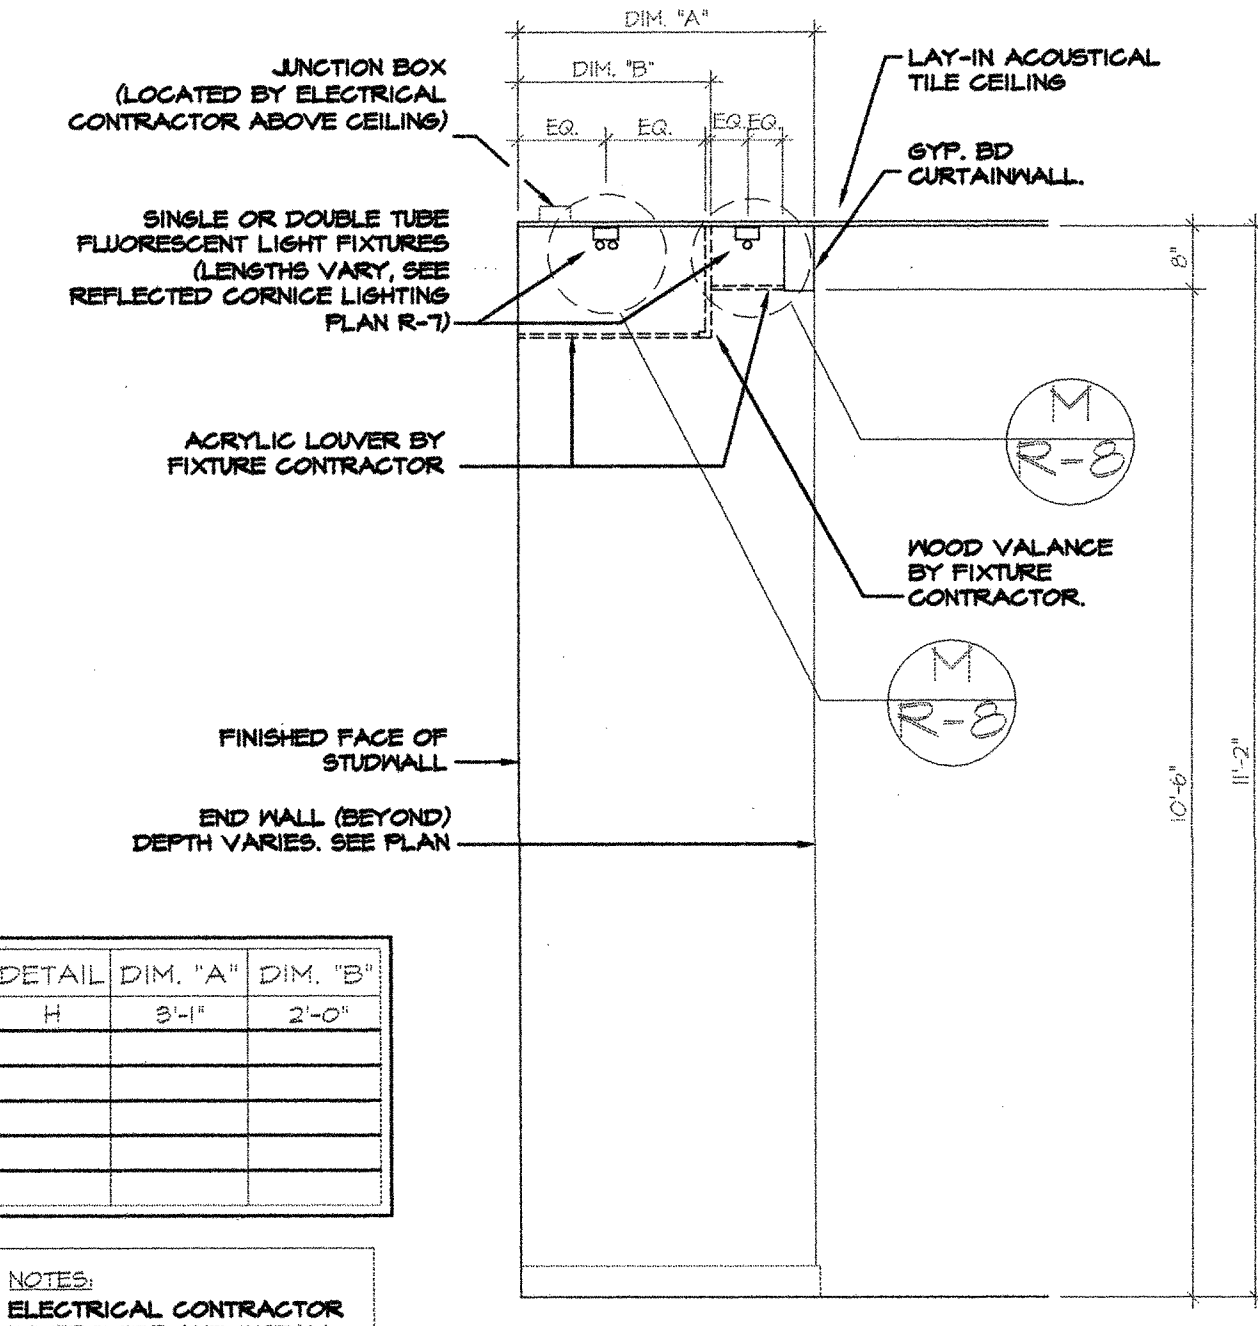

| DETAIL DIM. 'A' | DIM. 'B' |
|-----------------|-------------|
| I | 3'-4" 2'-0" |
| | |
| | |
| | |
| | |

NOTES:
ELECTRICAL CONTRACTOR TO PROVIDE AND INSTALL LIGHT FIXTURES. REFER TO ELECTRICAL PLANS FOR QUANTITIES AND SPECIFICATIONS.

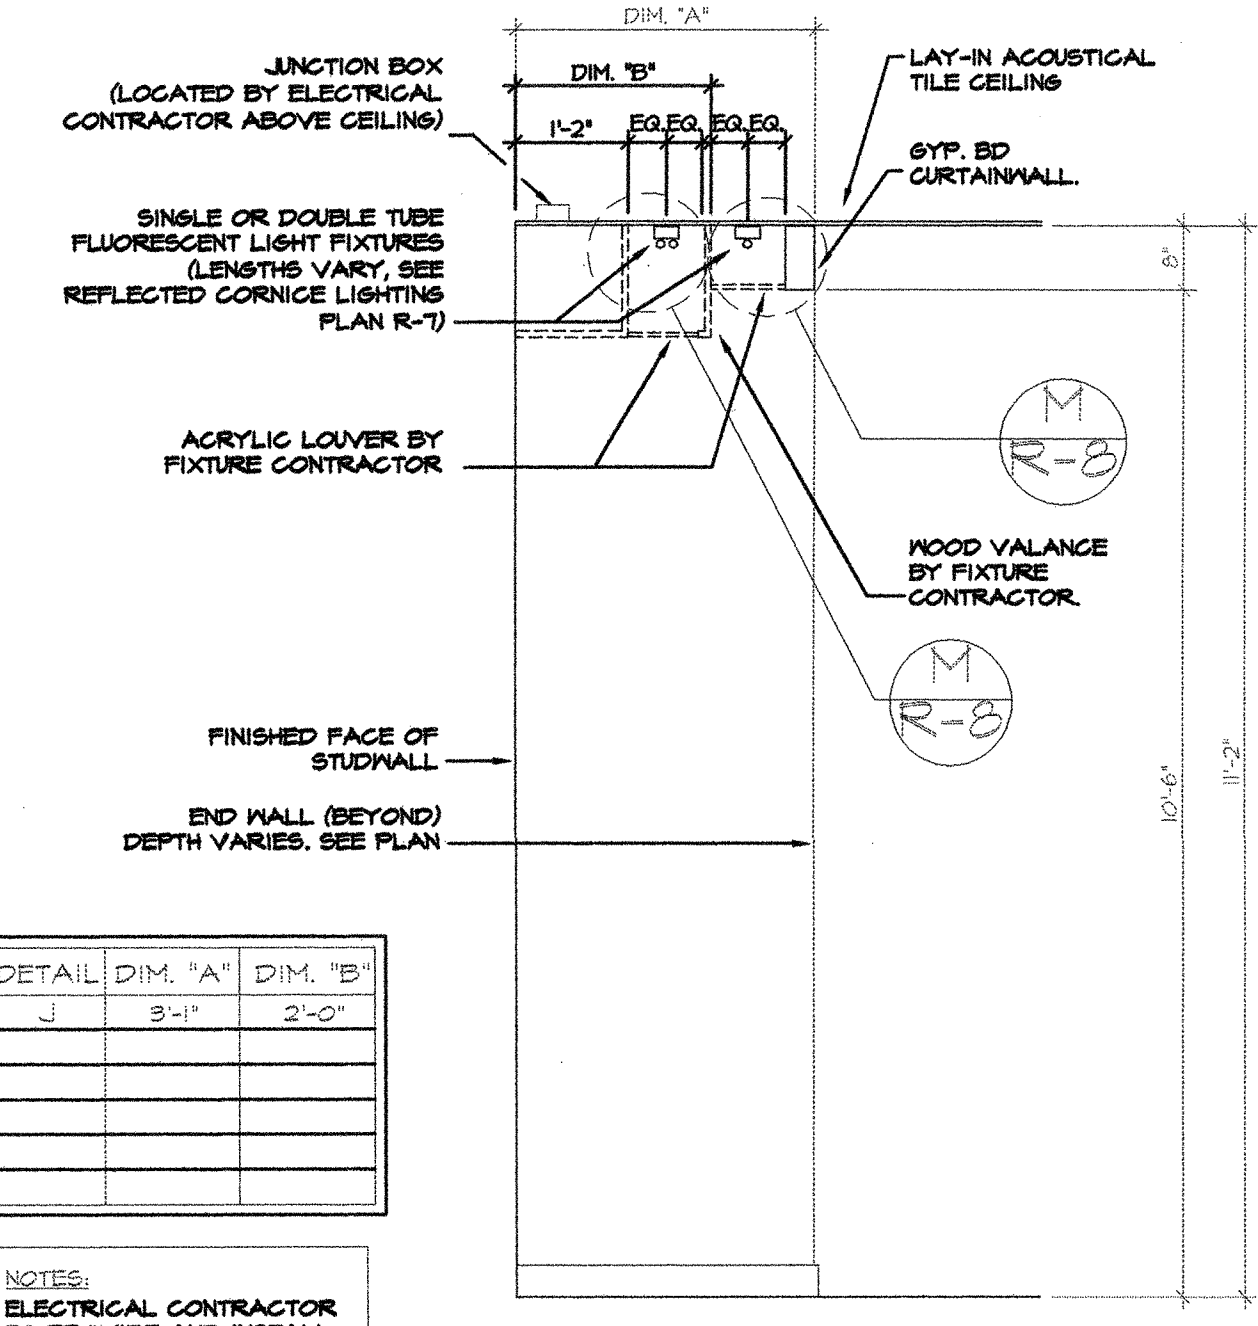

| DETAIL DIM. 'A' | DIM. 'B' |
|-----------------|-------------|
| J | 3'-4" 2'-0" |
| | |
| | |
| | |
| | |

NOTES:
ELECTRICAL CONTRACTOR TO PROVIDE AND INSTALL LIGHT FIXTURES. REFER TO ELECTRICAL PLANS FOR QUANTITIES AND SPECIFICATIONS.


B LIGHTING SECTION
SCALE: 1/2" = 1'-0"

E LIGHTING SECTION
SCALE: 1/2" = 1'-0"


G LIGHTING SECTION
SCALE: 1/2" = 1'-0"

I LIGHTING SECTION
SCALE: 1/2" = 1'-0"


J LIGHTING SECTION
SCALE: 1/2" = 1'-0"

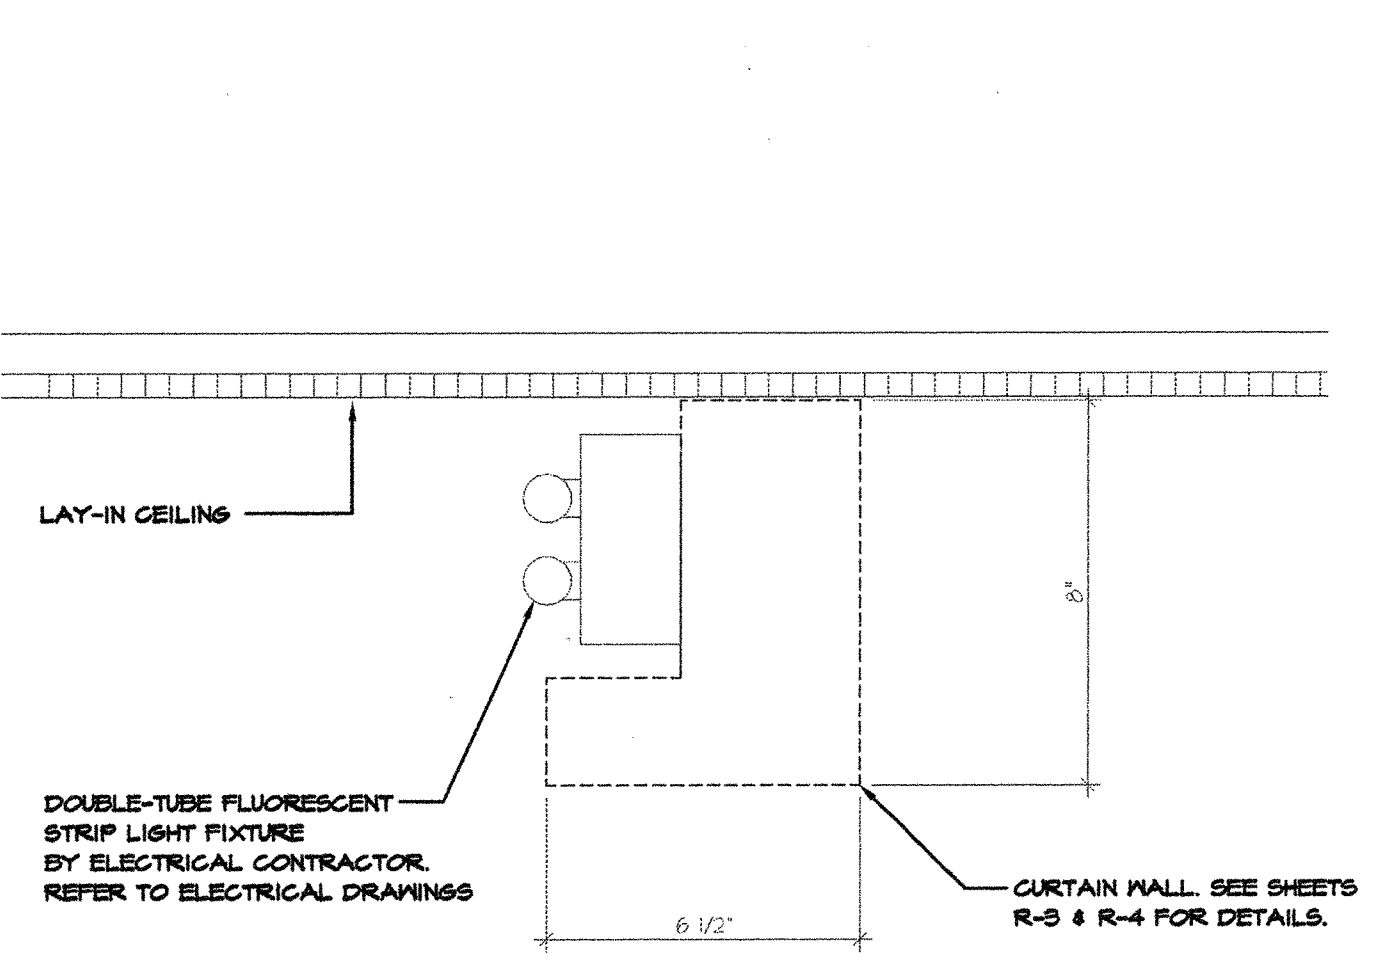

K DETAIL
SCALE: 3" = 1'-0"

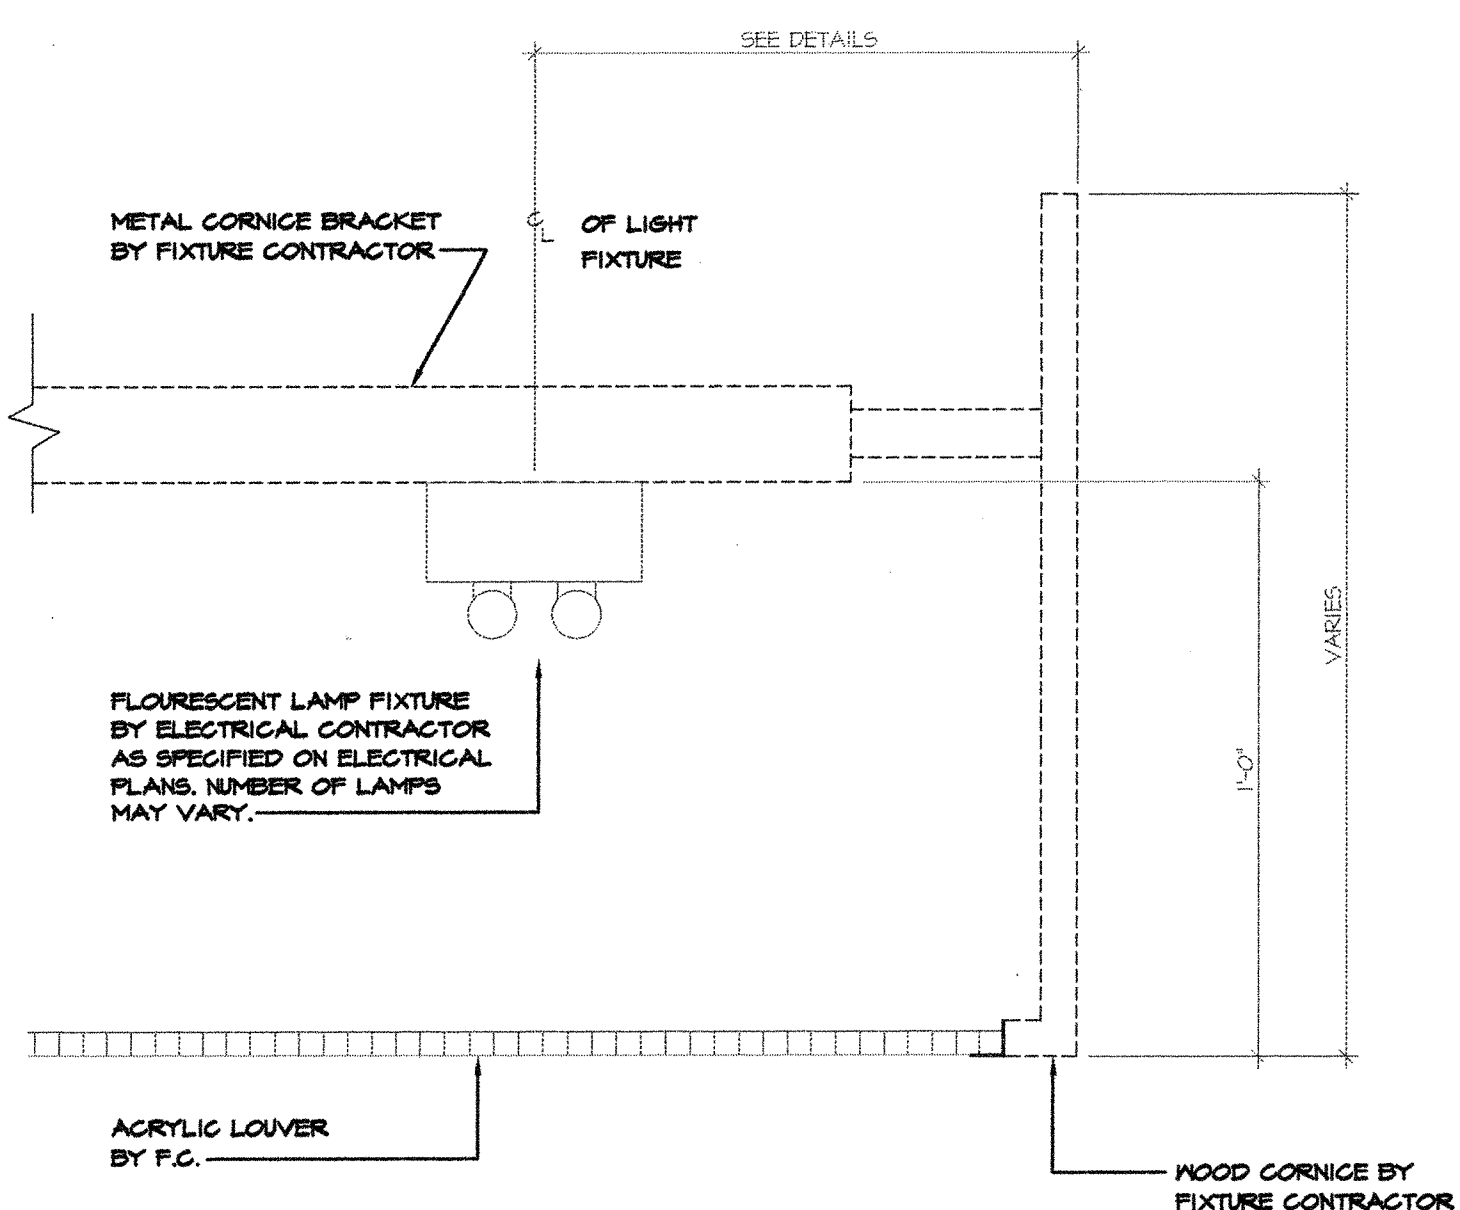

L DETAIL
SCALE: 3" = 1'-0"

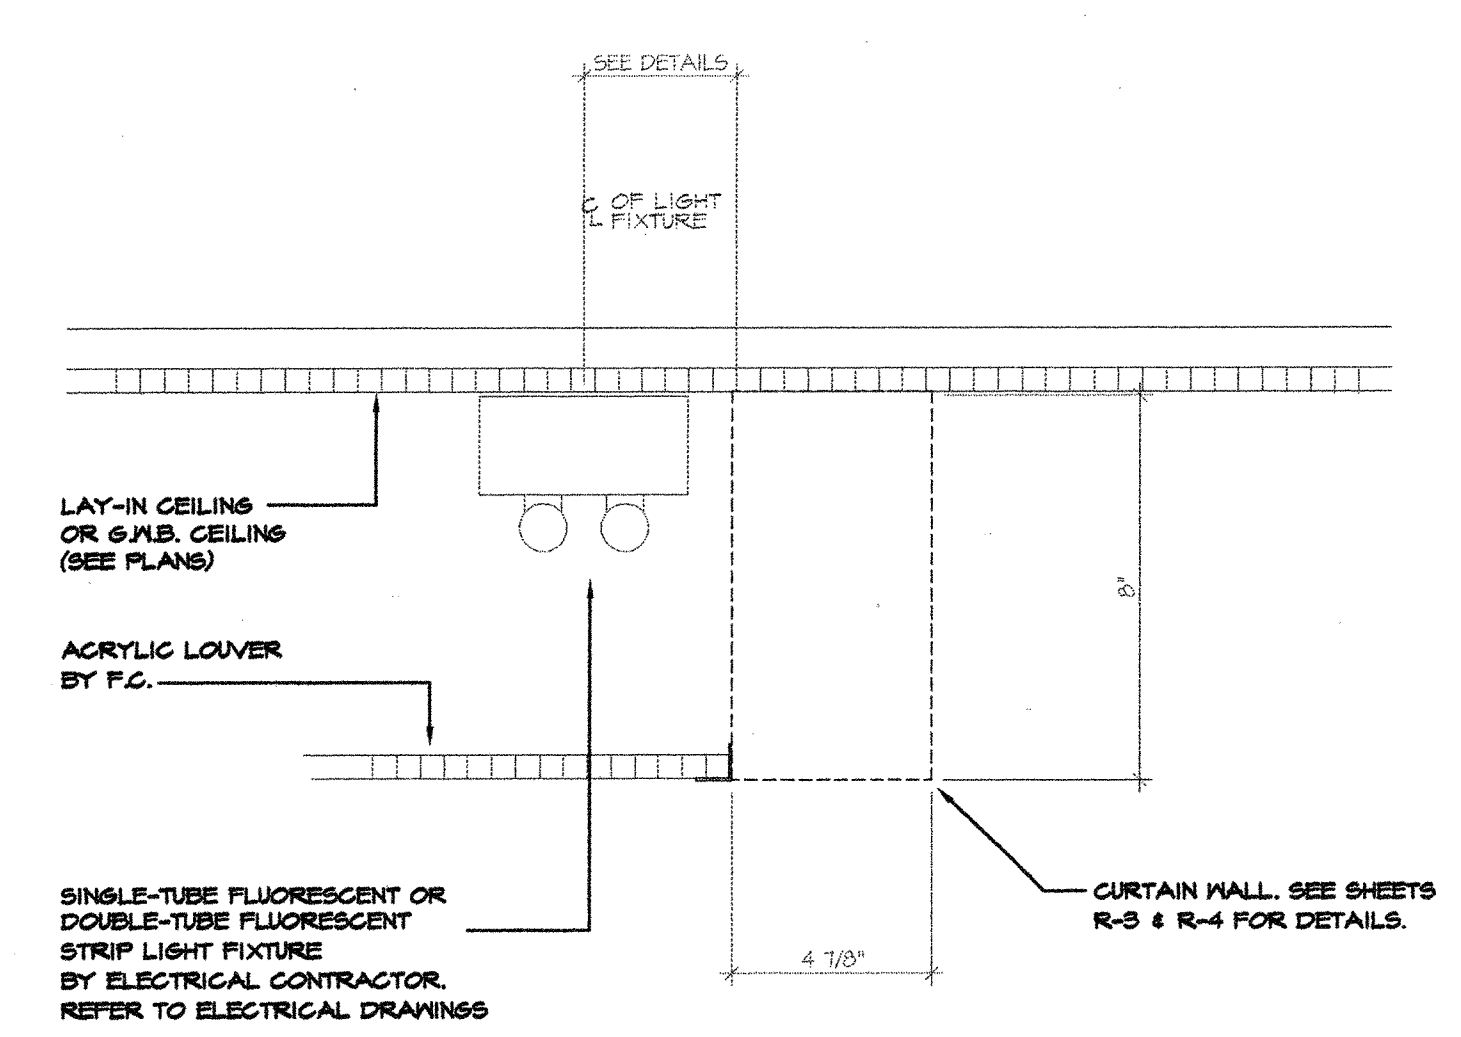

M DETAIL
SCALE: 3" = 1'-0"

REGISTERED ARCHITECT
STATE OF TEXAS
1928
2-87107
EXPIRES: 7/31/99
AFFIXED: 2/17/99

RPDC RETAIL PLANNING DESIGN GROUP
 112 W. WASHINGTON ST. SUITE 100
 GREENVILLE, TX 76744
 (767) 855-8589 FAX (767) 542-9023
 CONSULTANTS
 PROJECT: BELK CROSSROADS MALL GREENVILLE, TX NEW INSTALLATION
 SHEET TITLE: TYPICAL MALL AND CORNICE SECTIONS
 SHEET NUMBER: R-8
 OF 19 SHEETS
 ARCHITECTURAL SHEET NUMBER: E-7
 OF 19 SHEETS