


ROOM	SCHEDULE
100	GENERAL SALES
101	EXT. VESTIBULE
102	FITTING ROOM
103	STOCK ROOM
104	CORRIDOR
105	MALE RESTROOM
106	FEMALE RESTROOM
107	DISPLAY STORAGE
108	JANITOR
109	MARKING/RECEIVING
110	ASSOC. ENTRANCE
111	COAT/LOCKER
112	ASSOC. LOUNGE
113	ASM UTILITY
114	CORRIDOR
115	MANAGER OFFICE
116	CASH/AUDIT
117	COPIER/MAIL ROOM
118	TRAINING ROOM
119	FITTING ROOM
120	STOCK
121	STOCK/ELECTRICAL
122	FITTING ROOMS
123	CORRIDOR
124	STOCK
125	CORRIDOR
126	STOCK
127	ELECTRICAL ROOM
128	STOCK
129	STOCK
130	CORRIDOR
131	FITTING ROOMS
132	FITTING ROOMS
133	STOCK
134	STOCK
135	STOCK
136	FITTING ROOMS

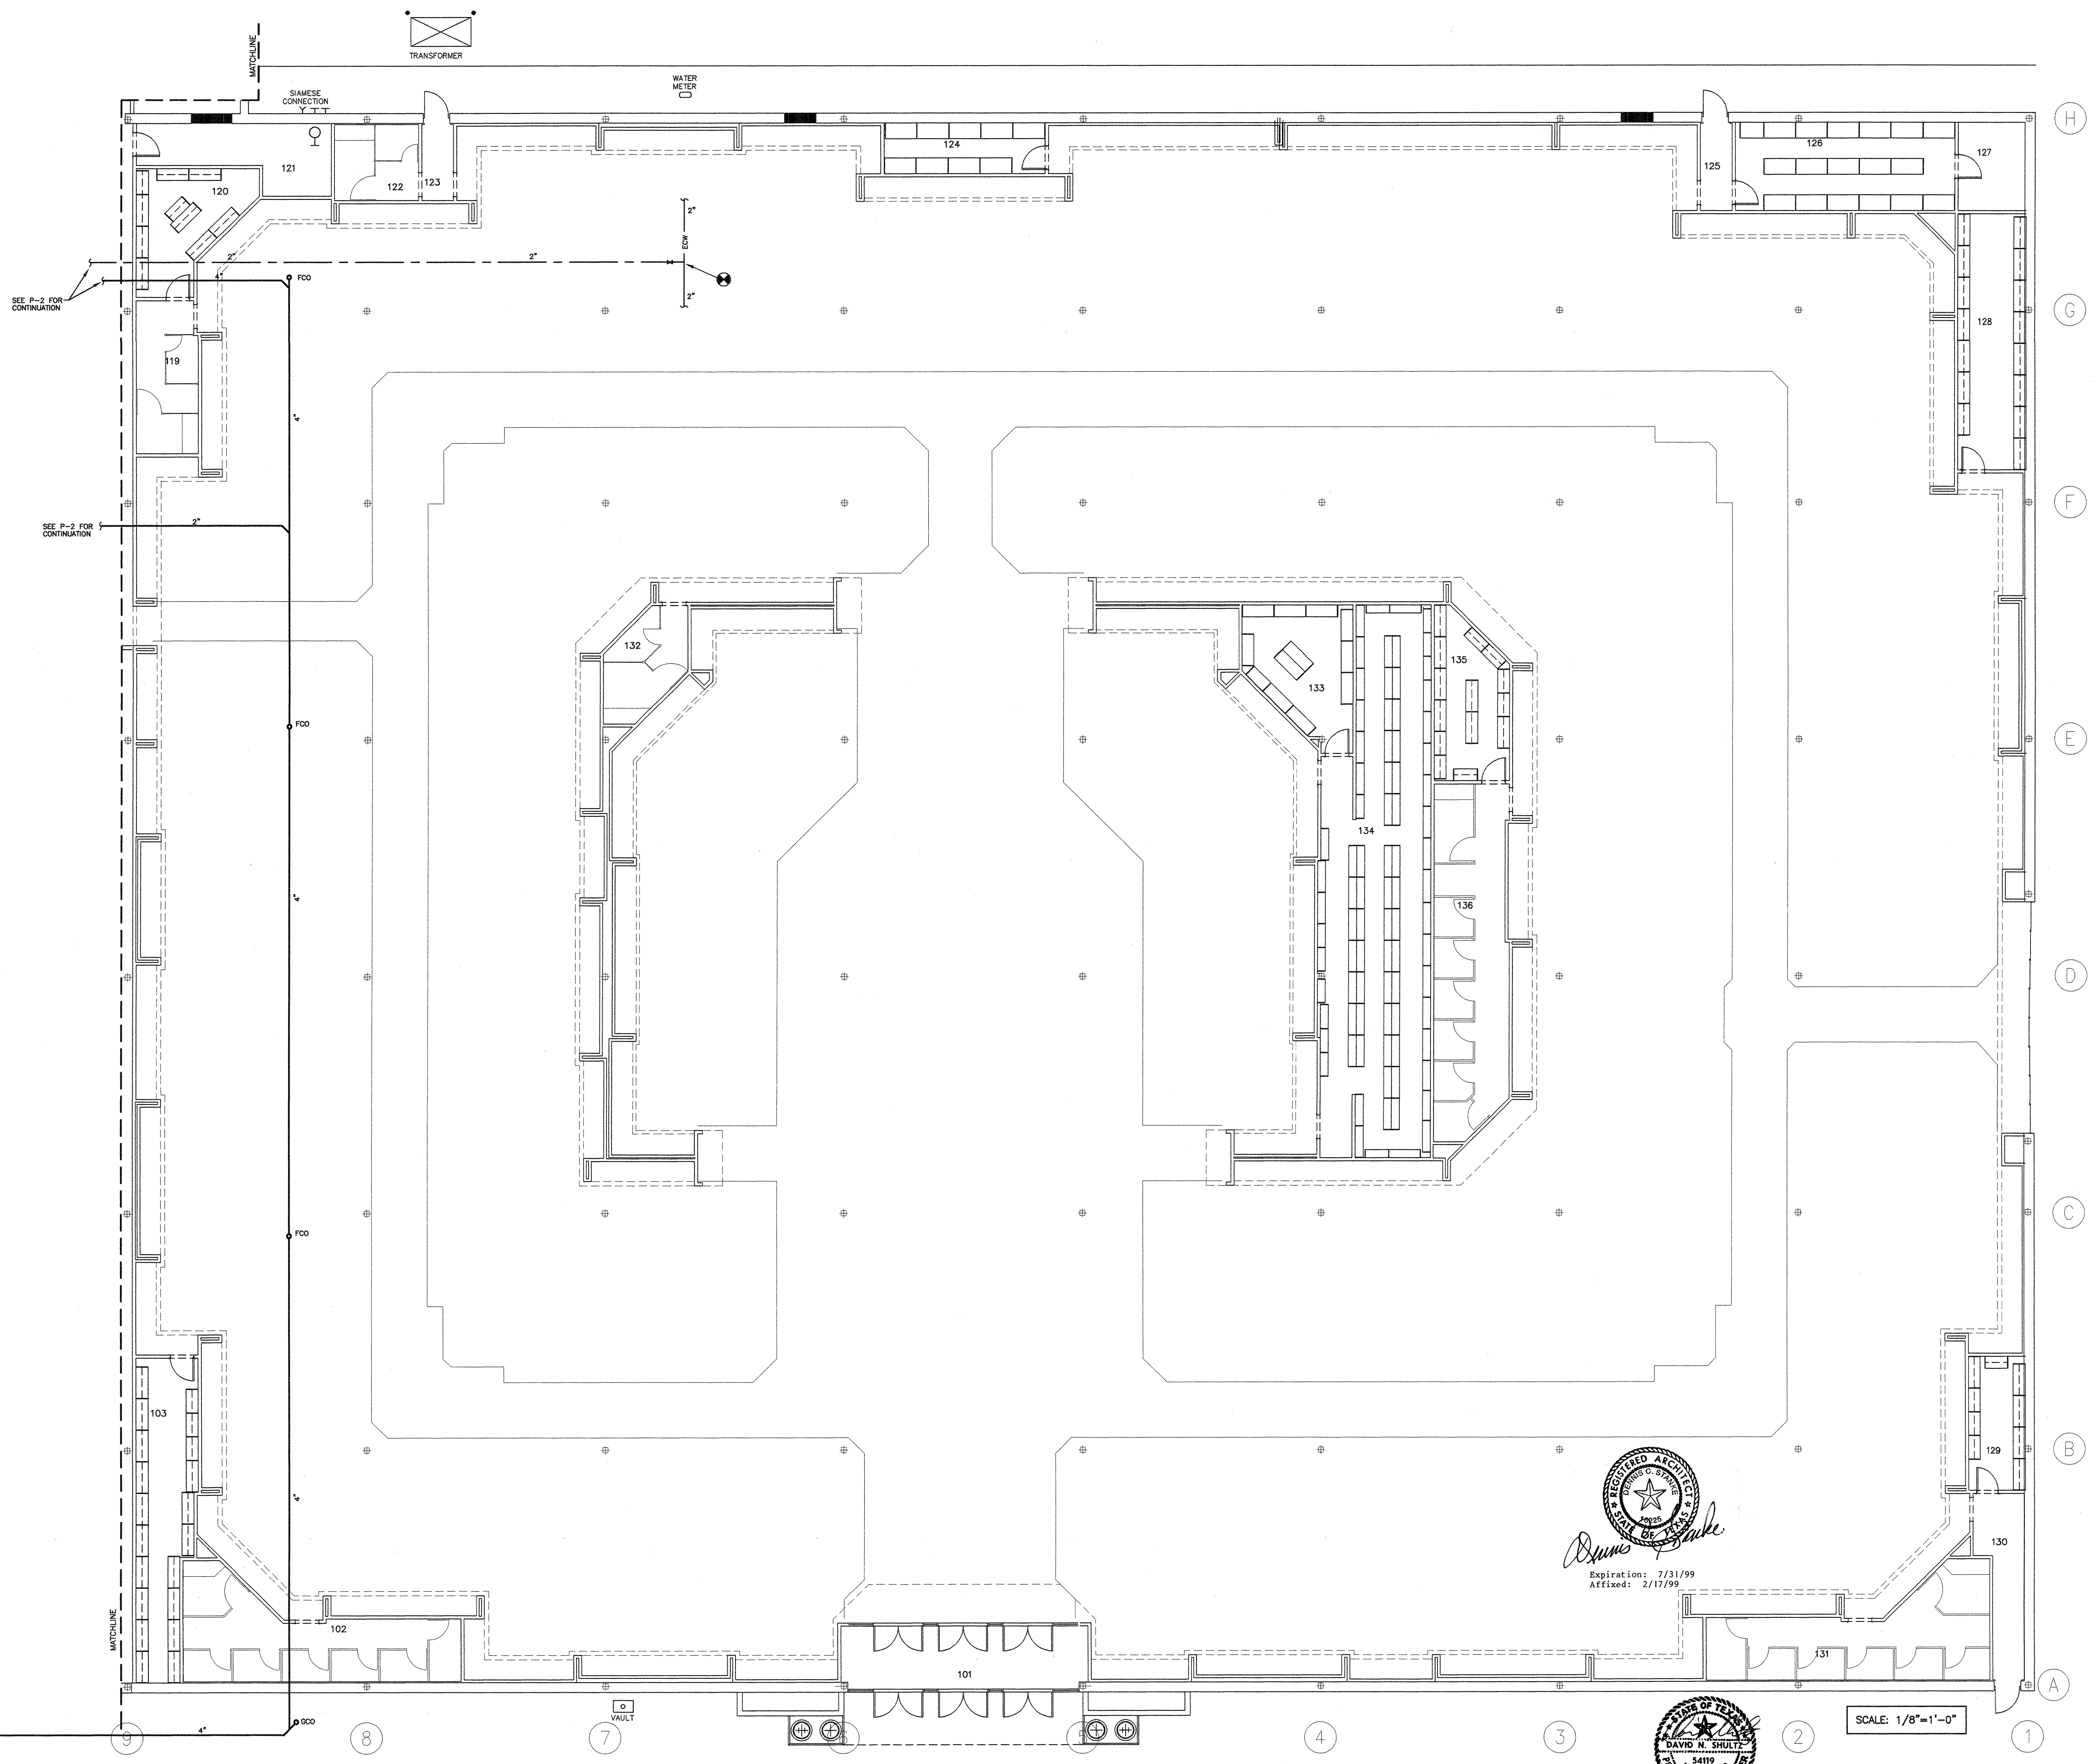

Expiration: 7/31/99
 Affixed: 2/17/99

STATE OF TEXAS
 REGISTERED PROFESSIONAL ENGINEER
 DAVID W. SHULTZ
 94119
 EXPIRES 7/31/99
 AFFIDAVIT 2/17/99

SCALE: 1/8"=1'-0"

RPDGC
 RETAIL PLANNING DESIGN GROUP
 2801 WESTYORK ROAD • CHARLOTTE, NC • 28217-4530 • TEL: (704) 357-8511

DAVID W. SHULTZ, P.E.
 REGISTERED PROFESSIONAL ENGINEER
 STATE OF TEXAS
 NO. 94119
 EXPIRES 7/31/99
 AFFIDAVIT 2/17/99

PROJECT: **WALMART CROSSROADS MALL**
 GREENVILLE, TX
 WALMART CONVERSION

SHEET TITLE: **PLUMBING FLOOR PLAN PART A**

NO.	DATE	BY	CHKD.	REVISED
1	1-4-99			
2				
3				
4				

OF 3 SHEETS
 ARCHITECTURAL SHEET NUMBER
P-1
 OF 3 SHEETS